



# Ripley's AQUARIUMS

## DESIGN DEVELOPMENT PACKAGE

**DESIGN DEVELOPMENT DRAWINGS**  
**\*\*\*NOT FOR CONSTRUCTION\*\*\***  
**FIELD VERIFY ALL MEASUREMENTS**

**SAVAGE SEAS CHANGEABLE**  
**GATLINBURG, TENNESSEE**  
**RIPLEY'S AQUARIUM OF THE SMOKIES - 2/2019**

### INDEX

101.1.1	KEY PLAN AND DIMENSION	11X17	101.2.15	ELEVATION B.7-B.8	11X17
101.1.2	FLOOR LAYOUT	11X17	101.2.16	ELEVATION B.9-B.10	11X17
101.1.3	FLOORING PLAN	11X17	101.2.17	ELEVATION C.1-C.3	11X17
101.1.4	ELECTRICAL PLAN	11X17	101.2.18	ELEVATION D.1-D.2	11X17
			101.2.19	ELEVATION D.3-D.4	11X17
<b>SHIP DECK/INDOOR</b>			<b>MILLWORK</b>		
101.2.1	ELEVATION A.1	11X17	101.3.1	PIRATE PHOTO OP	11X17
101.2.2	ELEVATION A.2	11X17	101.3.2	OCTOPUS PHOTO OP	11X17
101.2.3	ELEVATION B.1-B.3	11X17	101.3.3A	BILLY BONES INTERACTIVE	11X17
101.2.4	ELEVATION B.4	11X17	101.3.3B	BILLY BONES DETAILS	11X17
101.2.5	ELEVATION C.1	11X17	101.3.4A	SUB LAYOUT	11X17
101.2.6	ELEVATION C.2-D.1	11X17	101.3.4B	SUB CONCEPT	11X17
101.2.7	ELEVATION D.2-D.4	11X17	101.3.4C	SUB MILLWORK	11X17
101.2.8	ELEVATION D.5-D.7	11X17			
<b>MOTHER NATURE</b>					
101.2.9	ELEVATION A-B	11X17			
101.2.10	ELEVATION C-D	11X17			
<b>SHIPWRECKS</b>					
101.2.11	ELEVATION A	11X17			
101.2.12	ELEVATION A-B.2	11X17			
101.2.13	ELEVATION B.3-B.4	11X17			
101.2.14	ELEVATION B.5-B.6	11X17			

**RIPLEY**

ENTERTAINMENT, INC.  
 7576 KINGSPONTE PKWY #188  
 ORLANDO, FLORIDA 32819  
 (407) 345-8010

WWW.RIPLEYS.COM



**1 KEY PLAN**  
SCALE: 1/8" = 1'

**RIPLEY**  
ENTERTAINMENT, INC.  
7576 KINGSPONTE PKWY #188  
ORLANDO, FLORIDA 32819  
(407).345.8010  
  
WWW.RIPLEYS.COM


PROJECT LOCATION:  
**GATLINBURG, TN**  
  
NOTES:

PROJECT TITLE:

DATE:  
**2/19**  
REVISED DATE:  
  
SCALE: 1/8" = 1'

DRAWN BY:  
**CCOYLE**  
  
APPROVED BY:

SHEET #  
  
**101.1.1**  
KEY  
ELEVATION

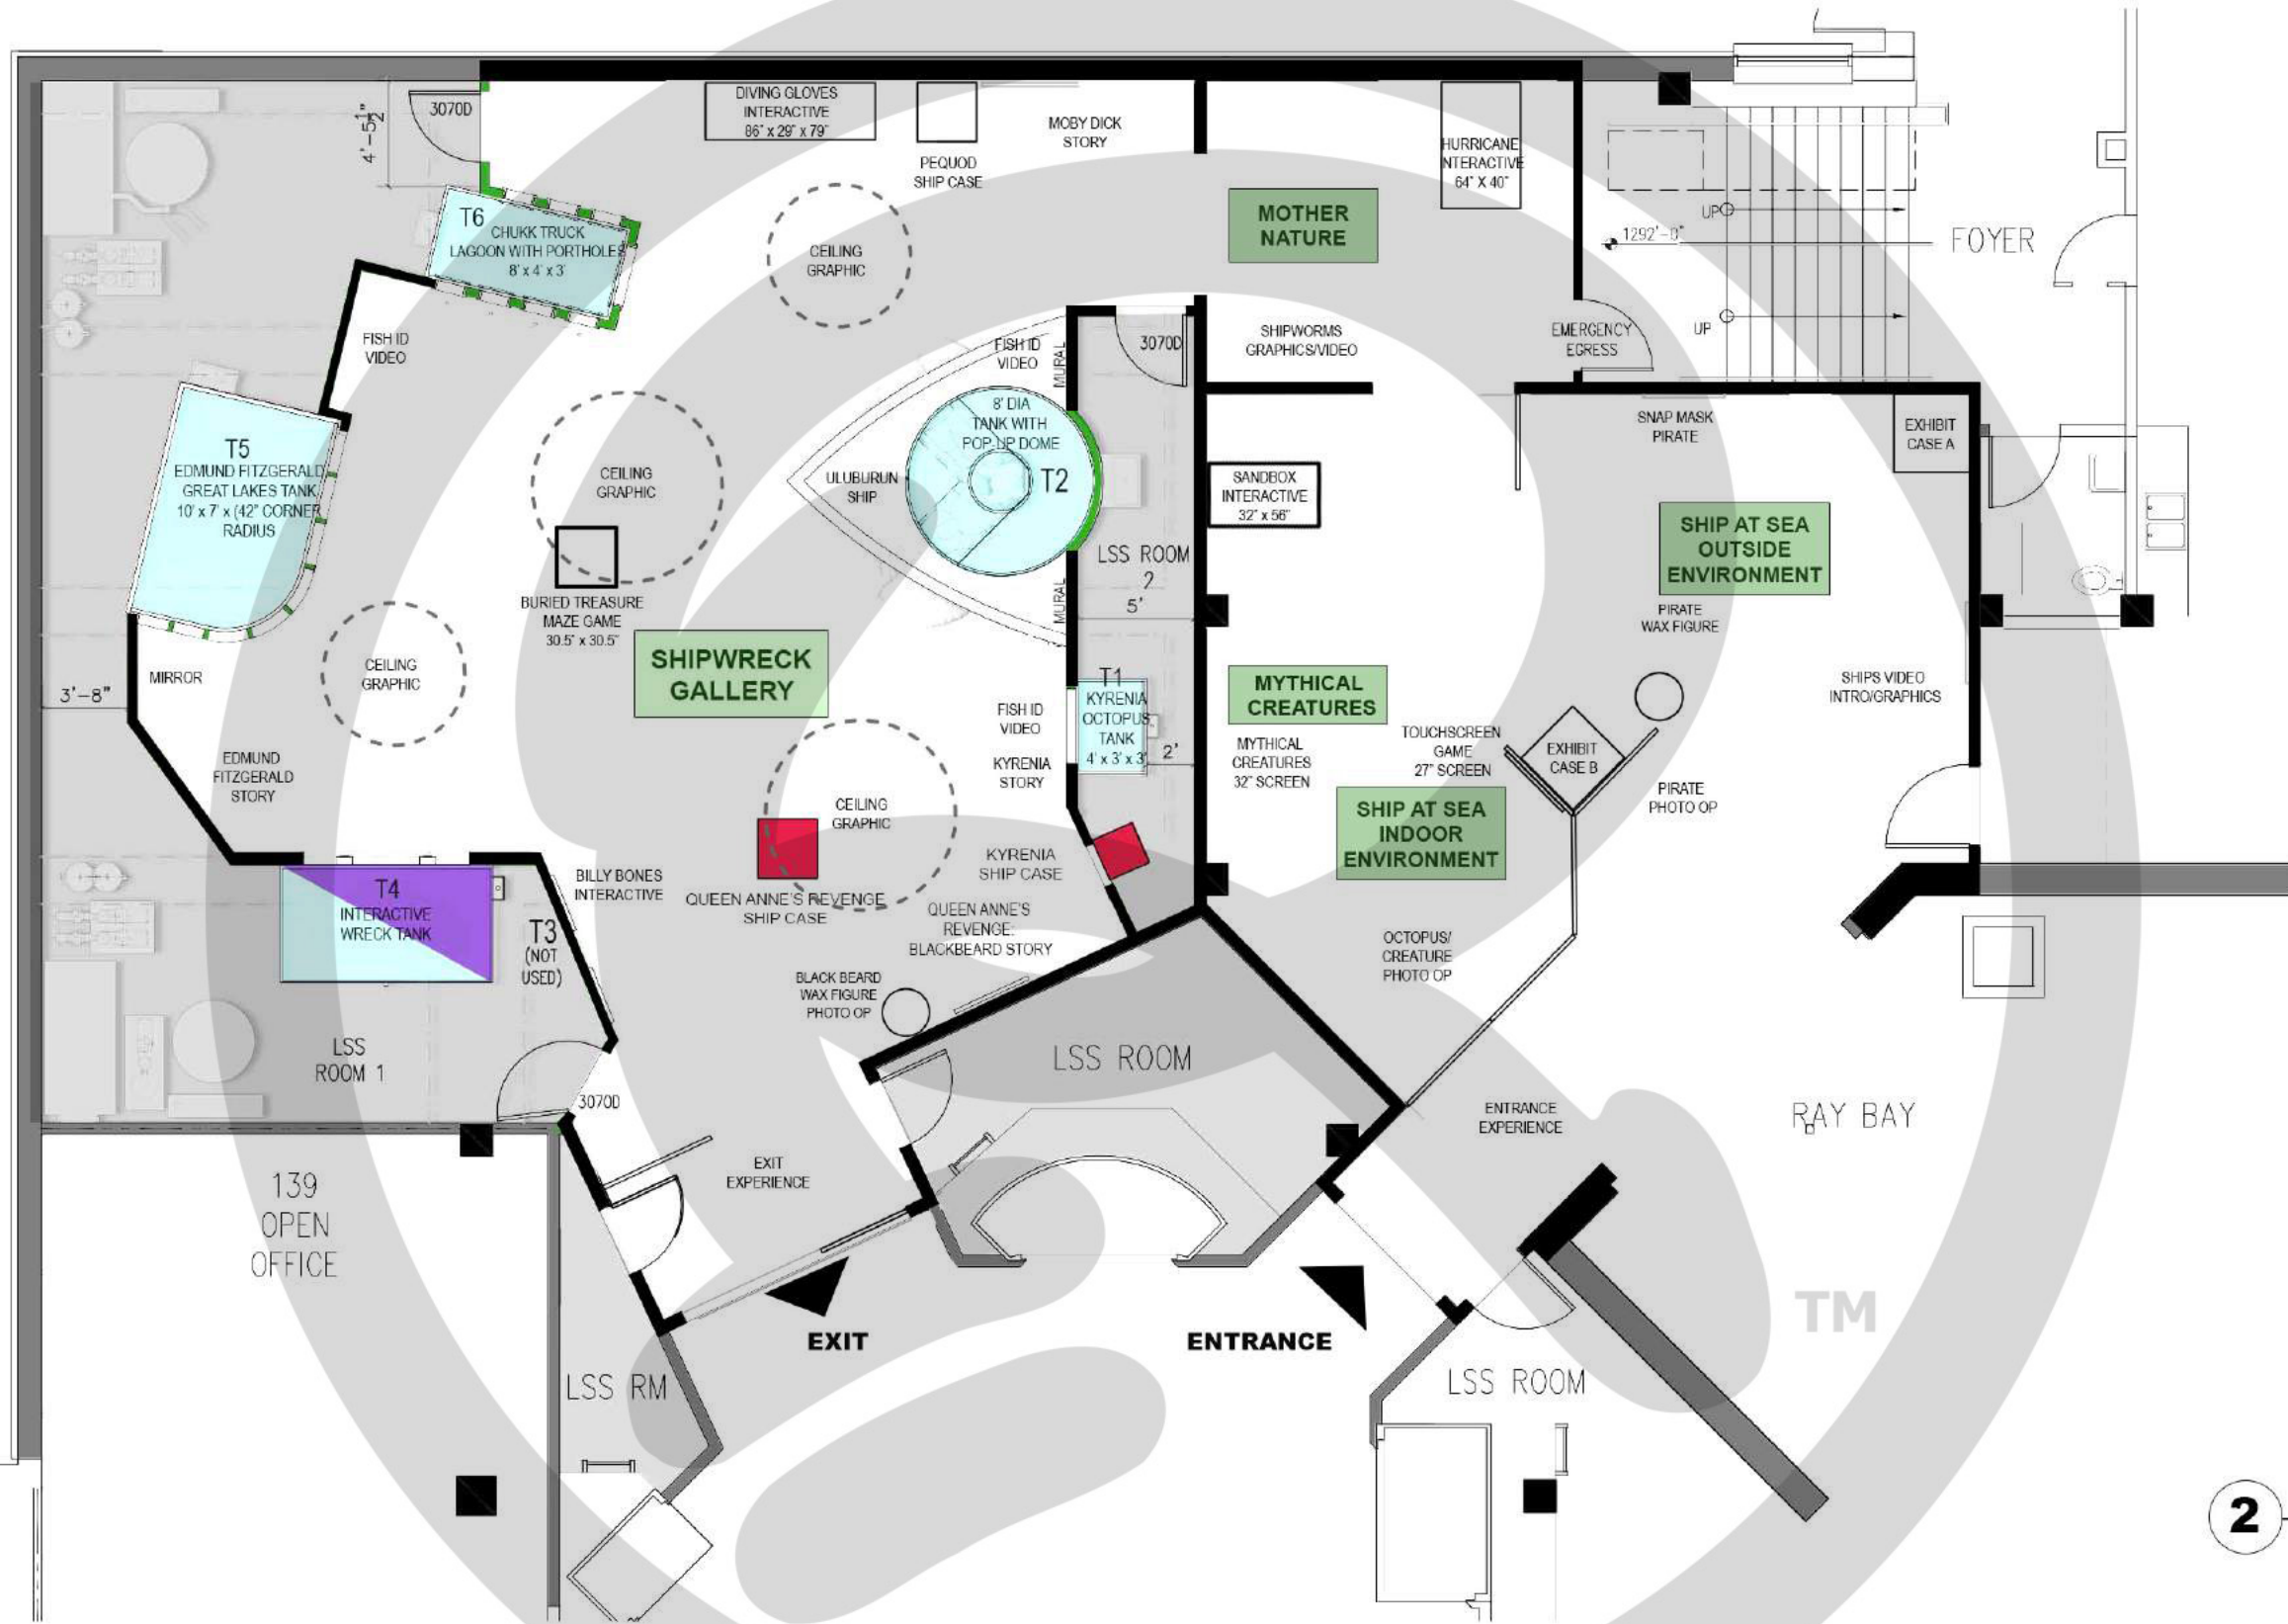

**2 LAYOUT PLAN**  
SCALE: 1/8" = 1'

**RIPLY**  
ENTERTAINMENT, INC.  
7576 KINGSPONTE PKWY #188  
ORLANDO, FLORIDA 32819  
(407).345.8010  
  
WWW.RIPLEYS.COM

PROJECT LOCATION:  
**GATLINBURG, TN**  
  
NOTES:

PROJECT TITLE:



DATE:  
**2/19**  
REVISED DATE:  
  
SCALE: 1/8" = 1'

DRAWN BY:  
**CCOYLE**  
  
APPROVED BY:

SHEET #  
  
**101.1.2**  
**LAYOUT PLAN**



**CARPET REFERENCE**

	[LVT-1] LUXURY VINYL TILE 1: CHESTNUT NATURAL WOODGRAINS COLLECTION REF# A00203 ASHLAR PATTERN INTERFACE.COM
	[C-1] CARPET 1: CEDAR WALK THE PLANK COLLECTION REF# 103959 ASHLAR PATTERN INTERFACE.COM

**LVT-1**  
58.8sq.ft.

**C-1**  
861sq.ft.

USE EXISTING  
CARPET

**3 FLOORING PLAN**  
SCALE: 1/8" = 1'

**RIPLEY**  
ENTERTAINMENT, INC.  
7576 KINGSPONTE PKWY #188  
ORLANDO, FLORIDA 32819  
(407).345.8010  
  
WWW.RIPLEYS.COM


PROJECT LOCATION:  
**GATLINBURG, TN**  
  
NOTES:

PROJECT TITLE:  


DATE:  
**2/19**  
REVISED DATE:  
  
SCALE: 1/8" = 1'

DRAWN BY:  
**CCOYLE**  
  
APPROVED BY:

SHEET #  
  
**101.1.3**  
**FLOORING**  
**PLAN**

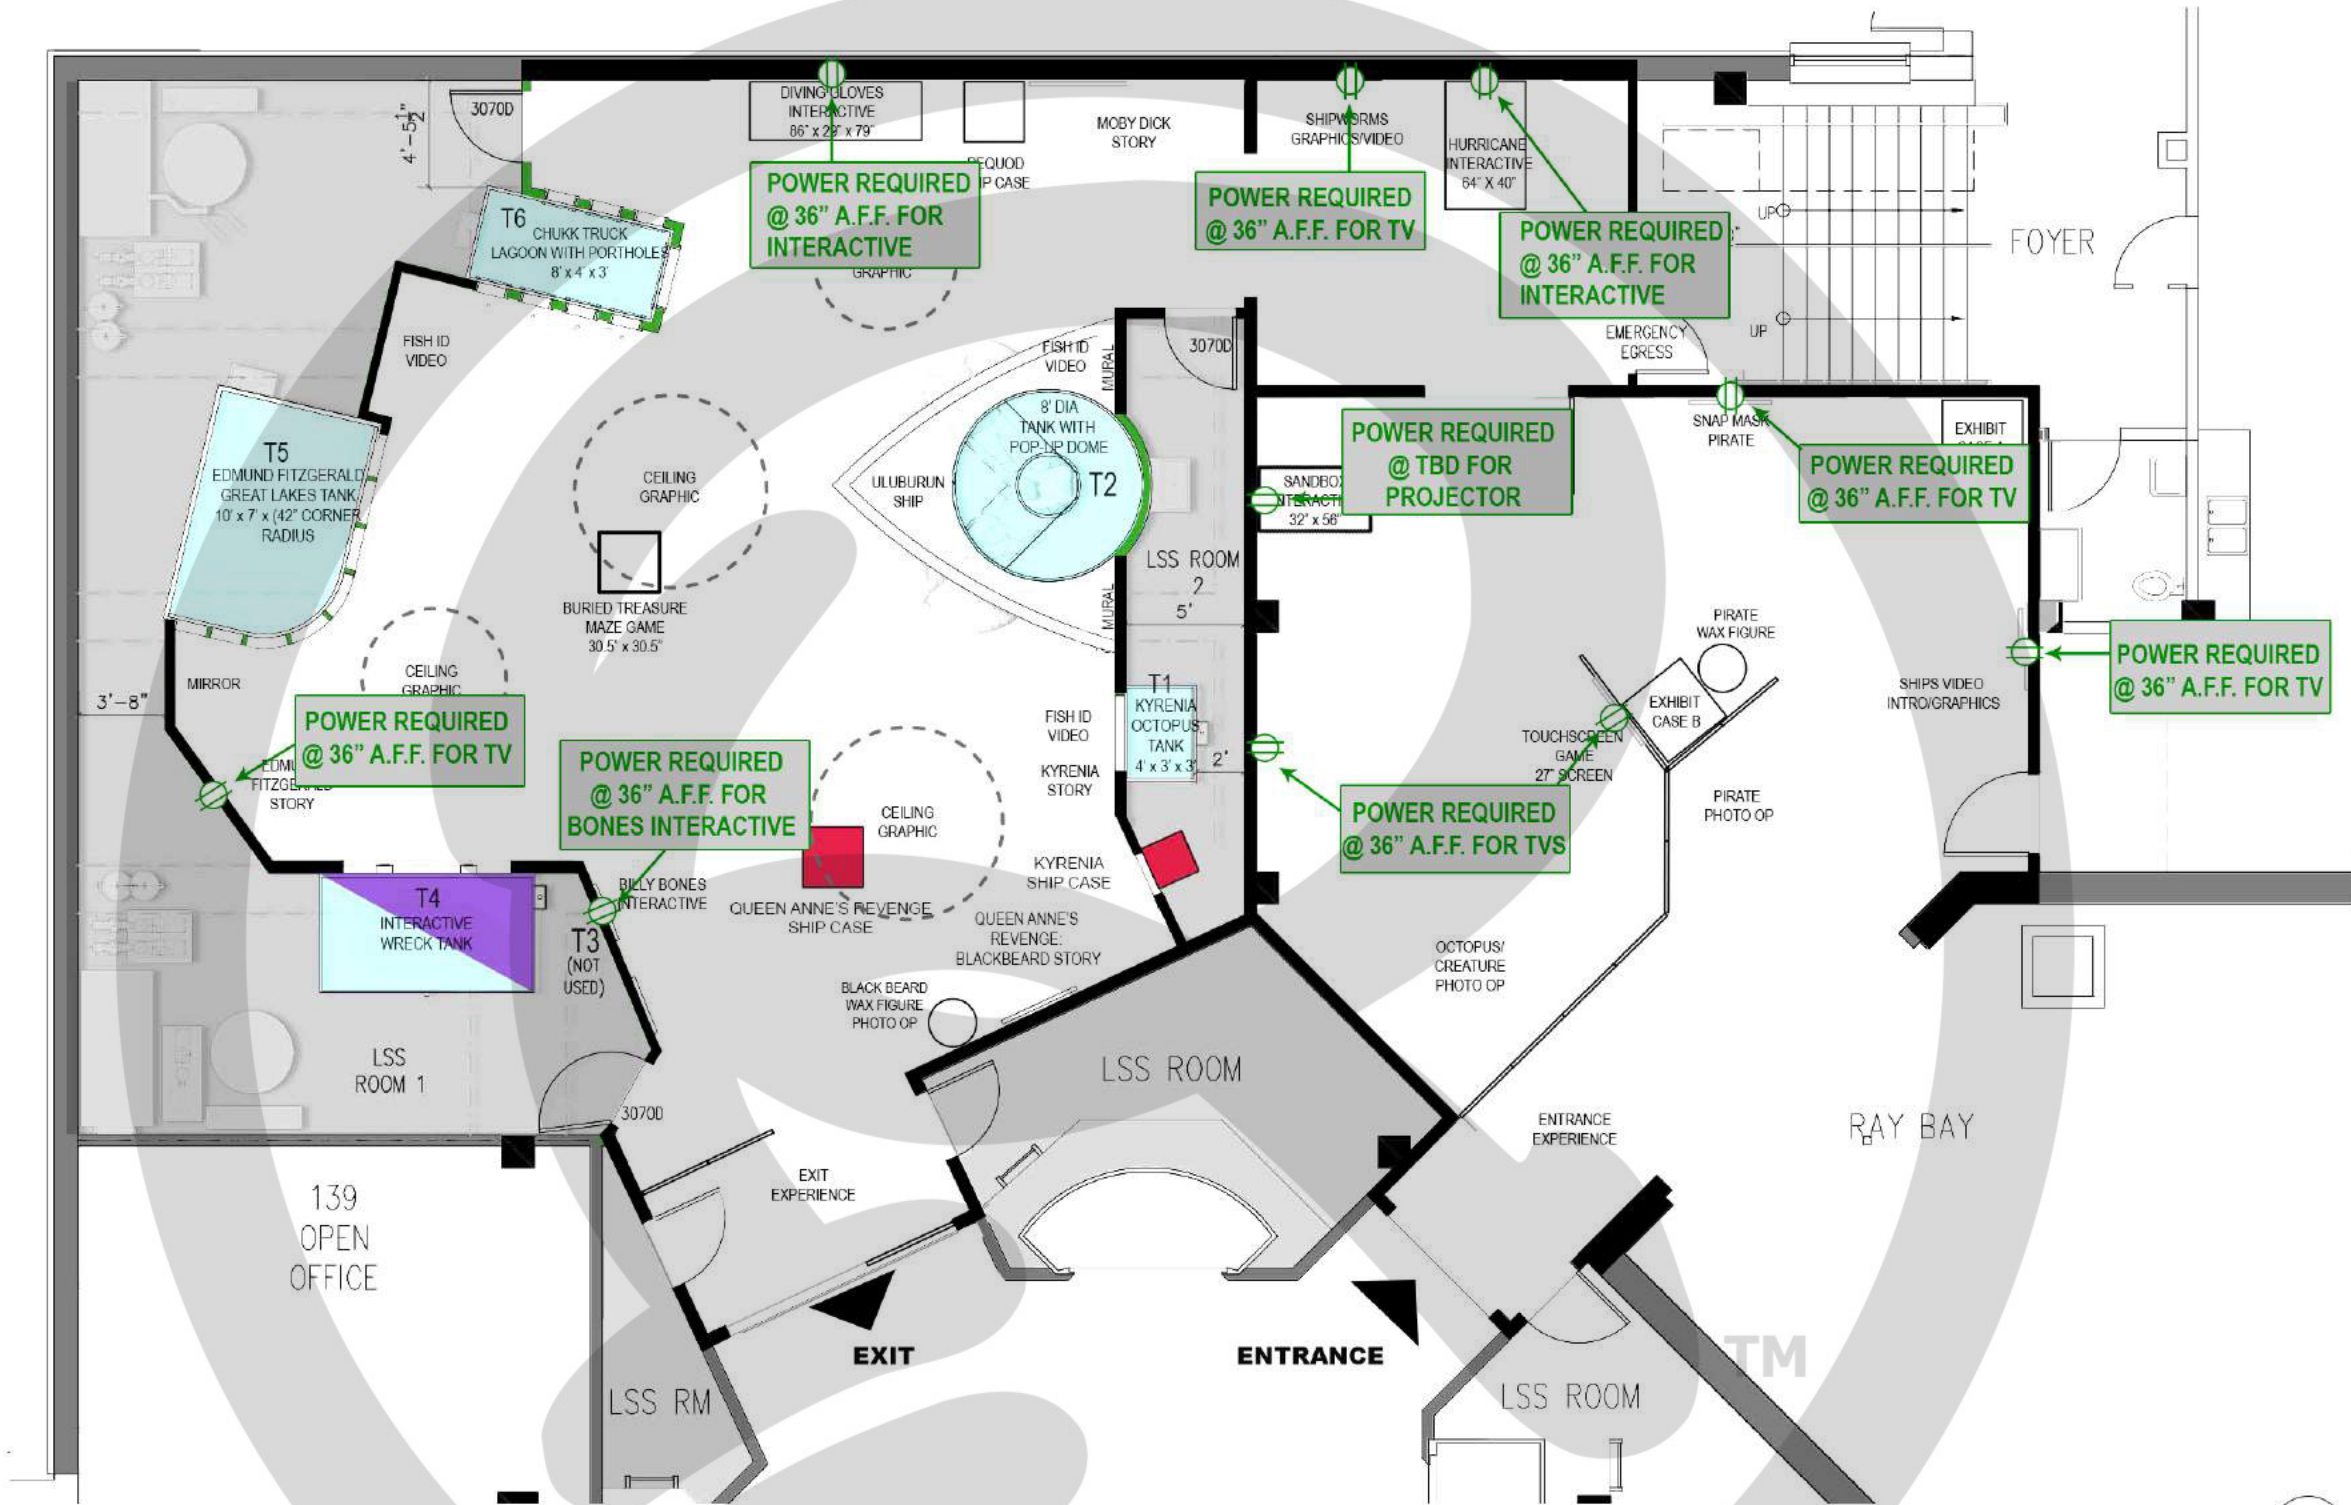

**4 ELECTRICAL PLAN**  
SCALE: 1/8" = 1'

**RIPLEY**  
ENTERTAINMENT, INC.  
7576 KINGSPORTE PKWY #188  
ORLANDO, FLORIDA 32819  
(407).345.8010  
  
WWW.RIPLEYS.COM

PROJECT LOCATION:  
**GATLINBURG, TN**  
  
NOTES:


PROJECT TITLE:




DATE:  
**2/19**  
REVISED DATE:  
  
SCALE: 1/8" = 1'

DRAWN BY:  
**CCOYLE**  
  
APPROVED BY:

SHEET #  
  
**101.1.4**  
**ELECTRICAL**  
**PLAN**

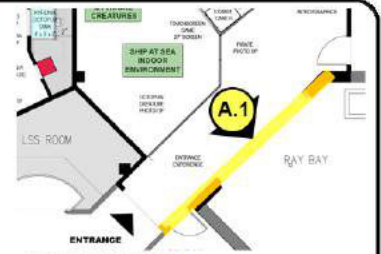

KEY ELEVATION  
SCALE: NOT TO SCALE

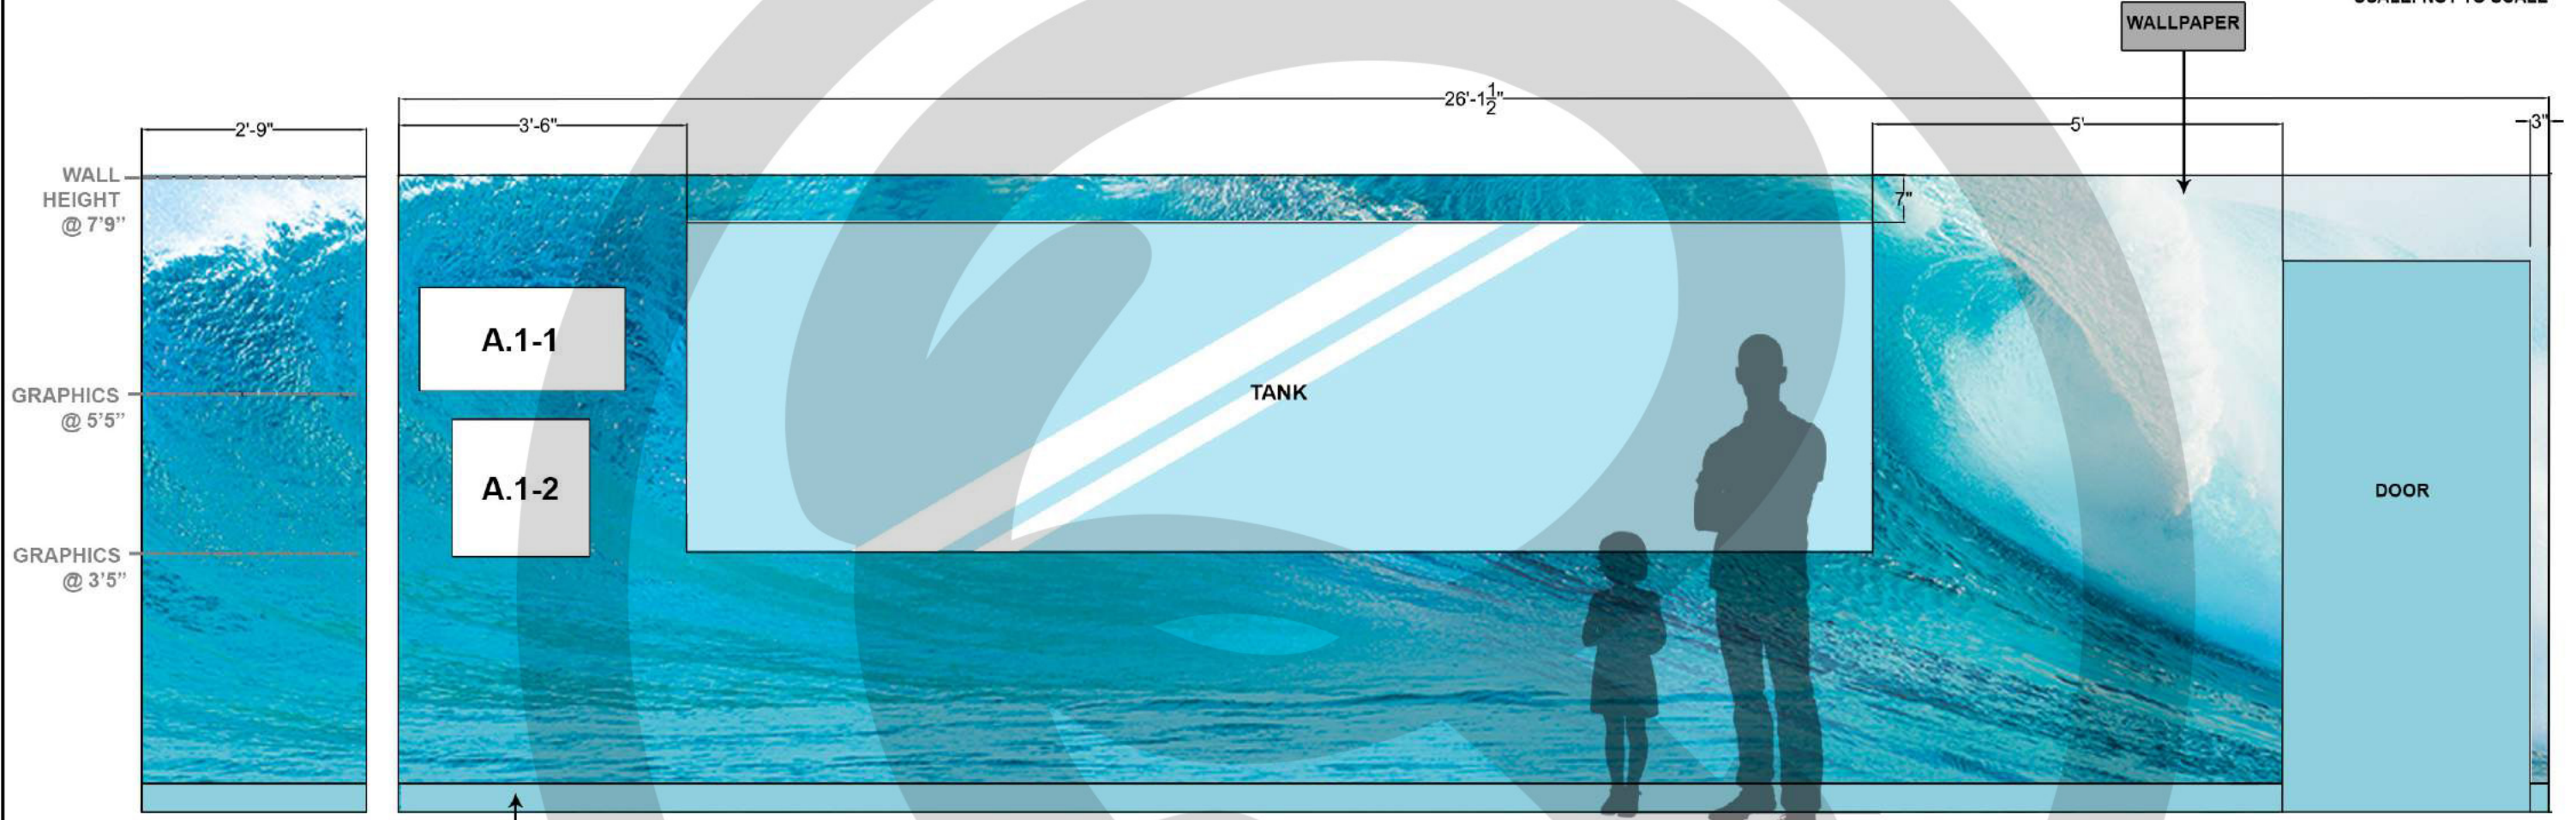

ELEVATION A.1

PAINT REFERENCE

**P-1 [PAINT 1]**  
**CLOUDLESS**  
**SW 6786**  
SATIN  
sherwin-williams.com

**5** SHIP DECK ELEVATION A.1  
SCALE: 1/2" = 1'

**RIPLEY**  
ENTERTAINMENT, INC.  
7576 KINGSPOINTE PKWY #188  
ORLANDO, FLORIDA 32819  
(407).345.8010  
  
WWW.RIPLEYS.COM

PROJECT LOCATION:  
**GATLINBURG, TN**  
  
NOTES:

PROJECT TITLE:  


DATE:  
**2/19**  
REVISED DATE:  
  
SCALE: 1/2" = 1'

DRAWN BY:  
**CCOYLE**  
  
APPROVED BY:

SHEET #  
  
**101.2.1**  
**SHIP DECK**  
**ELEVATION A**



SCRIMSHAW EGG  
EXHIBIT #13814

EXHIBIT CASE E




CASE EXISTS FROM  
PRIOR DESIGN



EXHIBIT CASE A



KEY ELEVATION  
SCALE: NOT TO SCALE

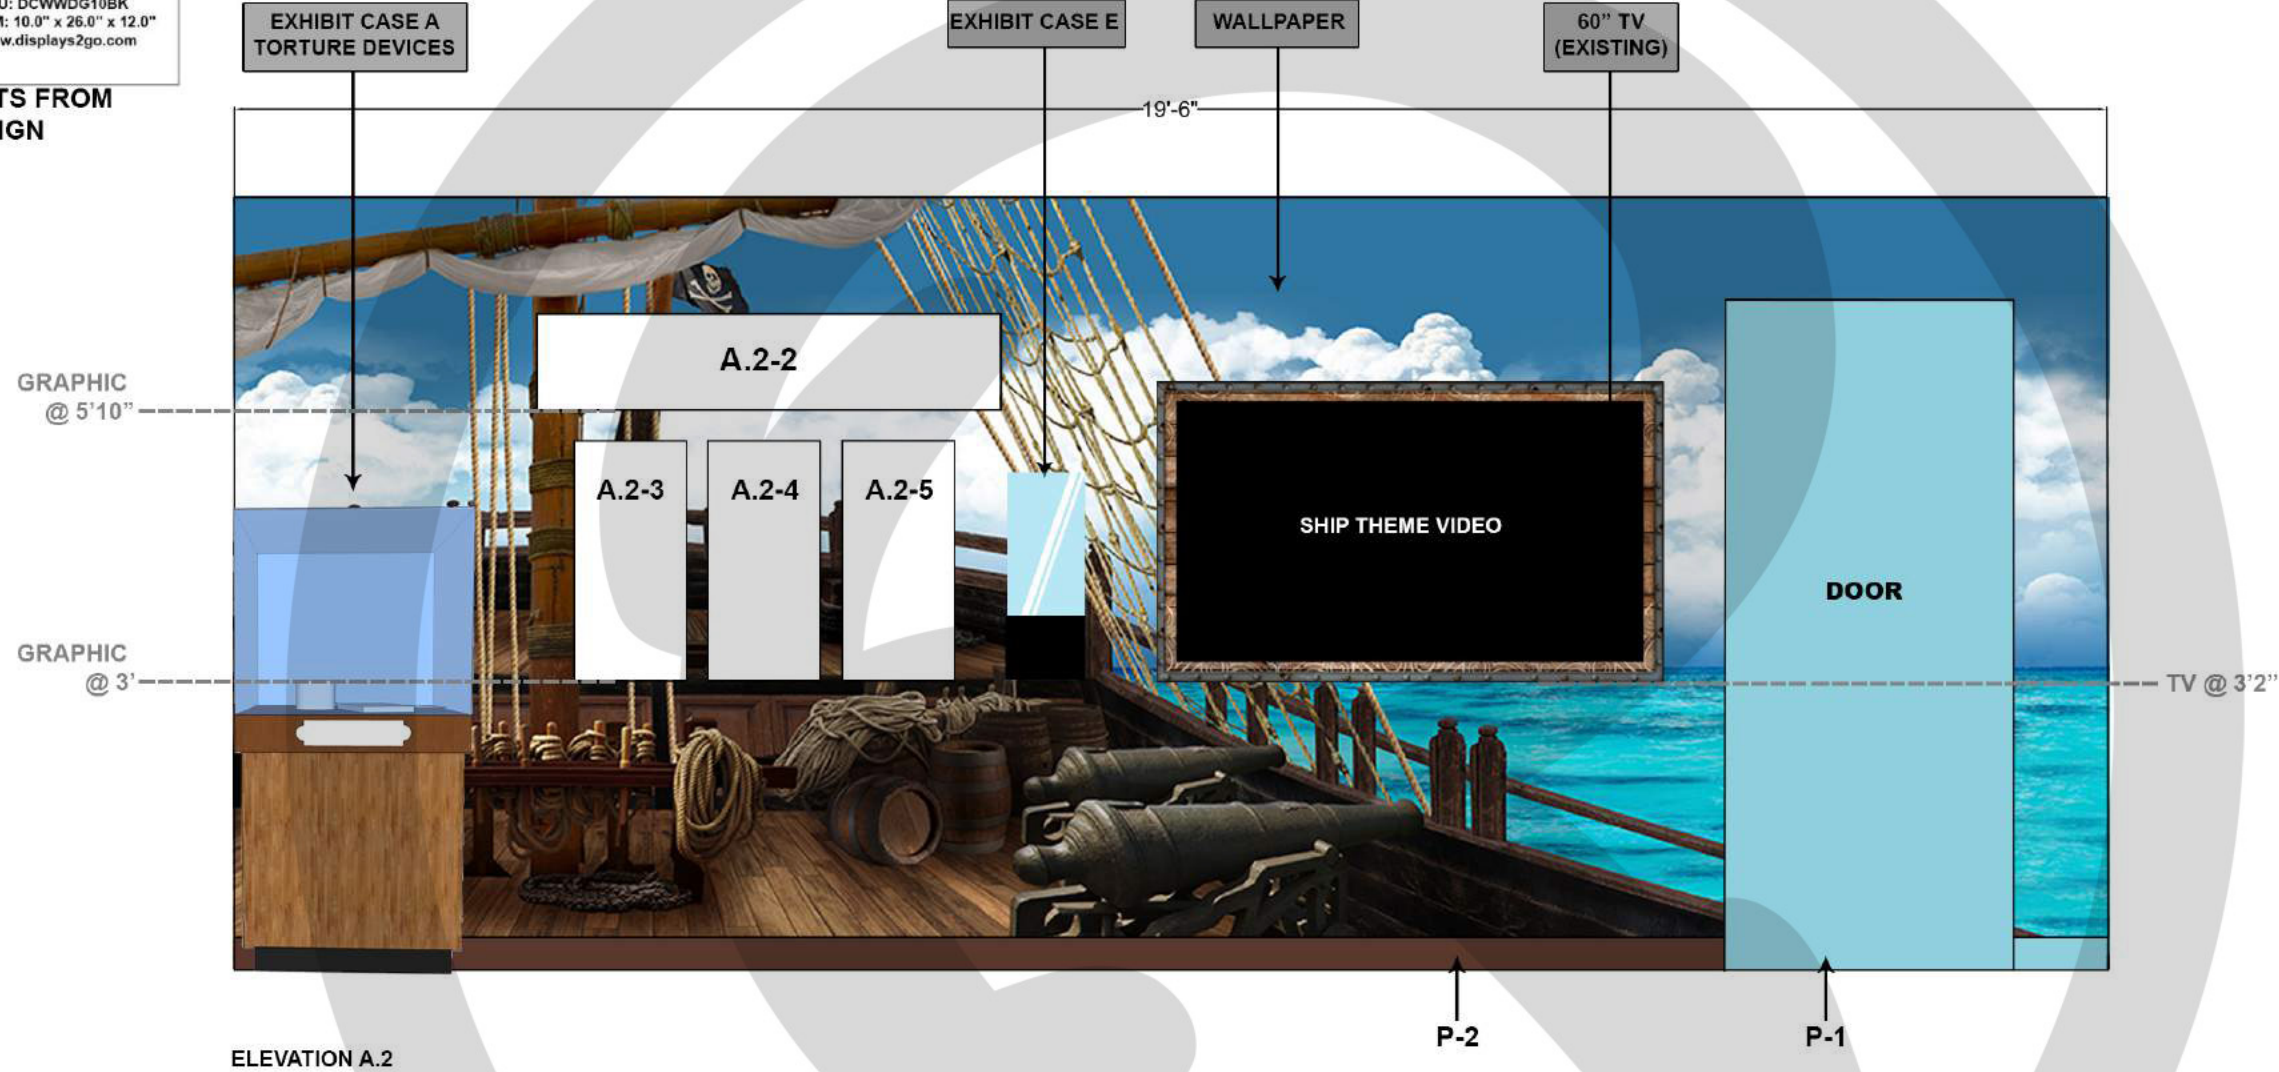

PAINT REFERENCE

**P-1 [PAINT 1]**  
**CLOUDLESS**  
 SW 6786  
 SATIN  
 sherwin-williams.com

**P-2 [PAINT 2]**  
**TERRA BRUN**  
 SW 6048  
 SATIN  
 sherwin-williams.com

**6** SHIP DECK-ELEVATION A.2  
SCALE: 1/2" = 1'

**RIPLEY**  
 ENTERTAINMENT, INC.  
 7576 KINGSPOINTE PKWY #188  
 ORLANDO, FLORIDA 32819  
 (407).345.8010  
 WWW.RIPLEYS.COM



PROJECT LOCATION:  
**GATLINBURG, TN**  
 NOTES:

PROJECT TITLE:

DATE:  
**2/19**  
 REVISED DATE:  
 SCALE: 1/2" = 1'

DRAWN BY:  
**CCOYLE**  
 APPROVED BY:

SHEET #  
**101.2.2**  
**SHIP DECK**  
**ELEVATION A.2**

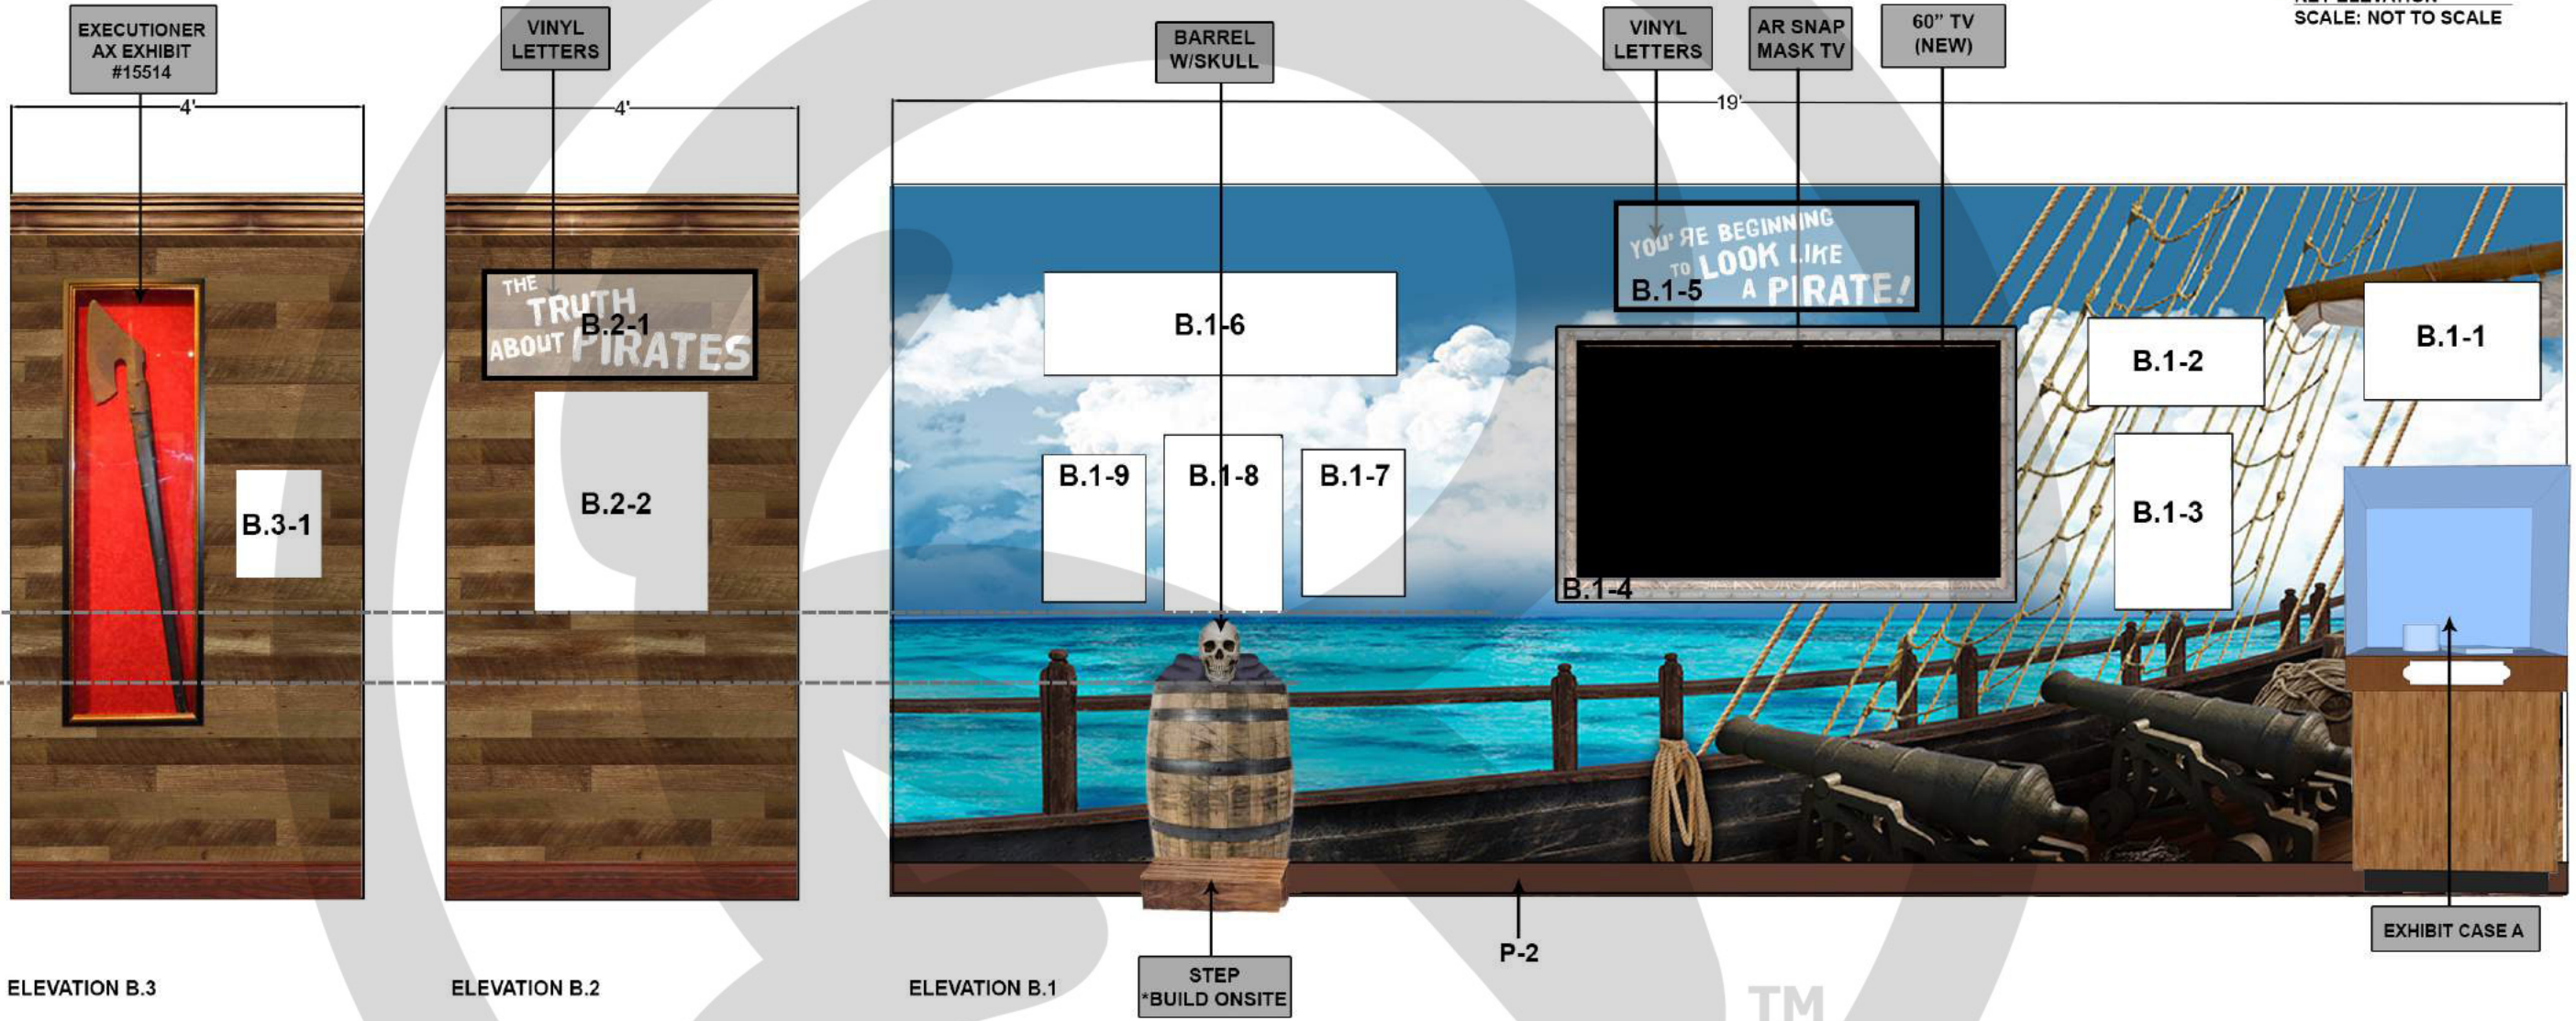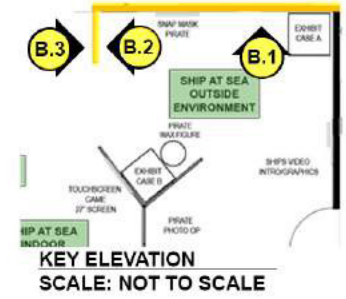

GRAPHICS @ 3'3"  
SKULL BARREL HEIGHT @ 2'5"

**PAINT REFERENCE**

**P-2 [PAINT 2]**  
**TERRA BRUN**  
**SW 6048**  
SATIN  
sherwin-williams.com



**Barrel with skull**  
\*Build step onsite  
**STEP DIMENSIONS**  
20"w x 7"h x 18"d

**7** SHIP DECK-ELEVATION B.1-B.3  
SCALE: 1/2" = 1'

**RIPLEY**  
ENTERTAINMENT, INC.  
7576 KINGSPOINTE PKWY #188  
ORLANDO, FLORIDA 32819  
(407).345.8010  
  
WWW.RIPLEYS.COM

PROJECT LOCATION:  
**GATLINBURG, TN**  
  
NOTES:

PROJECT TITLE:

DATE:  
**2/19**  
REVISED DATE:  
  
SCALE: 1/2" = 1'



DRAWN BY:  
**CCOYLE**  
  
APPROVED BY:

SHEET #  
  
101.2.3  
SHIP DECK  
ELEVATION  
B.1-B.3





**PO-1 [POSTER 1]  
CARTA MARINA  
FRAMED ART**

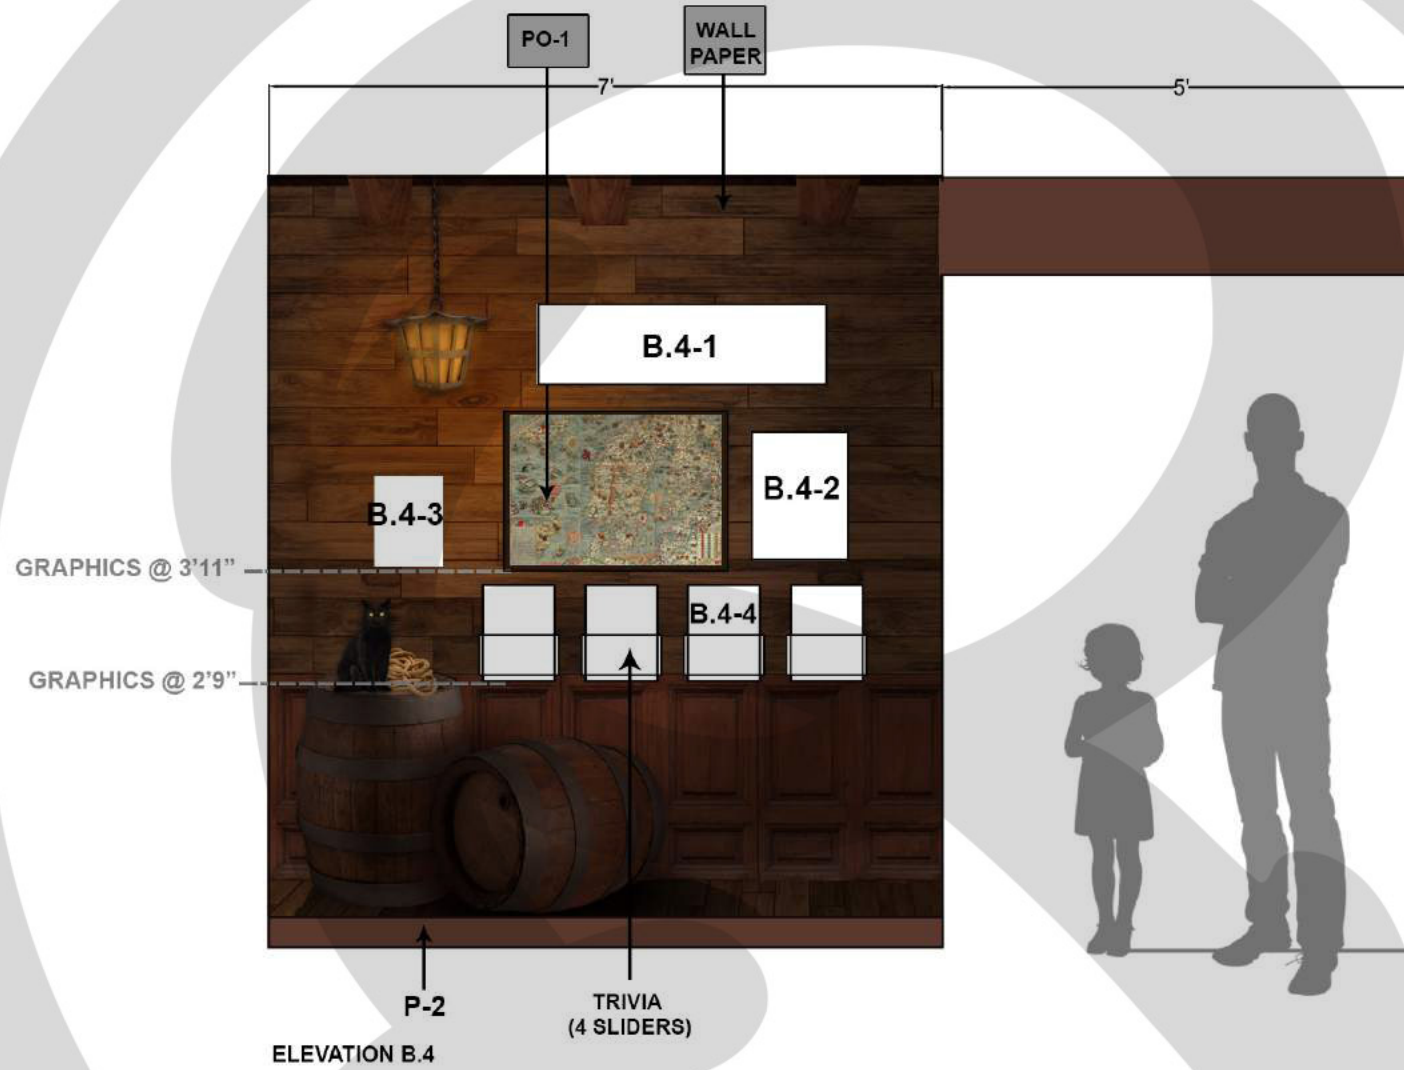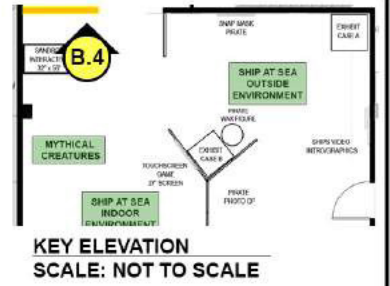

**PAINT REFERENCE**

**P-2 [PAINT 2]  
TERRA BRUN  
SW 6048  
SATIN  
sherwin-williams.com**

**8 SHIP INDOOR-ELEVATION B.4  
SCALE: 1/2" = 1'**

**RIPLEY**  
ENTERTAINMENT, INC.  
7576 KINGSPOINTE PKWY #188  
ORLANDO, FLORIDA 32819  
(407).345.8010  
  
WWW.RIPLEYS.COM


PROJECT LOCATION:  
**GATLINBURG, TN**  
  
NOTES:

PROJECT TITLE:


DATE:  
**2/19**  
REVISED DATE:  
  
SCALE: 1/2" = 1'

DRAWN BY:  
**CCOYLE**  
  
APPROVED BY:

SHEET #  
  
**101.2.4  
SHIP INDOOR  
ELEVATION B.4**

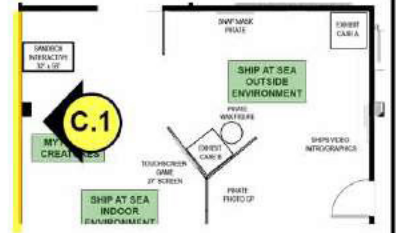

KEY ELEVATION  
SCALE: NOT TO SCALE

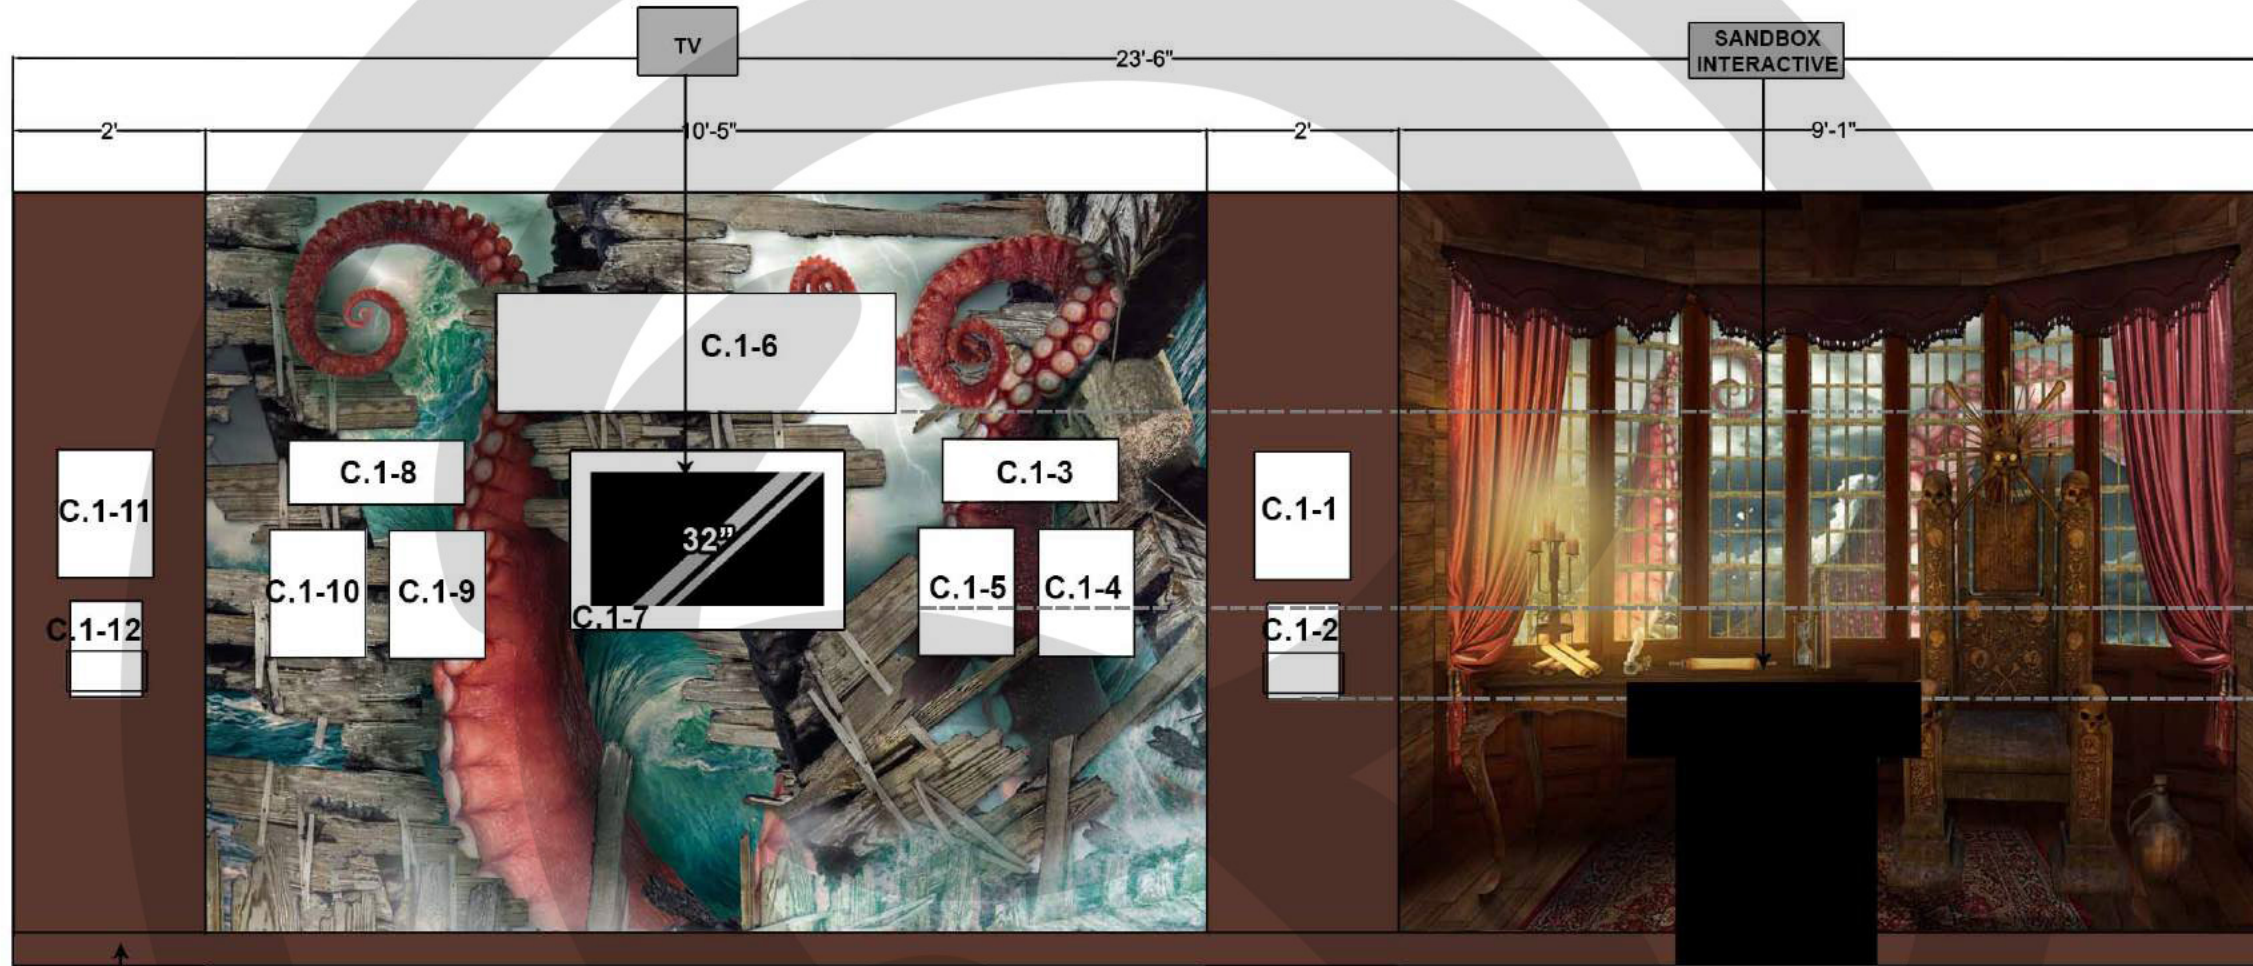

P-2  
ELEVATION C.1

GRAPHIC@ 5'9"  
TV@ 3'9"  
TRIVIA@ 2'9"

PAINT REFERENCE

**P-2 [PAINT 2]**  
**TERRA BRUN**  
 SW 6048  
 SATIN  
 sherwin-williams.com

9 SHIP INDOOR-ELEVATION C.1  
SCALE: 1/2" = 1'

**RIPLEY**  
 ENTERTAINMENT, INC.  
 7576 KINGSPOINTE PKWY #188  
 ORLANDO, FLORIDA 32819  
 (407).345.8010  
 WWW.RIPLEYS.COM


PROJECT LOCATION:  
**GATLINBURG, TN**  
 NOTES:

PROJECT TITLE:


DATE:  
**2/19**  
 REVISED DATE:  
 SCALE: 1/2" = 1'

DRAWN BY:  
**CCOYLE**  
 APPROVED BY:


SHEET #  
 101.2.5  
 SHIP INDOOR  
 ELEVATION C.1

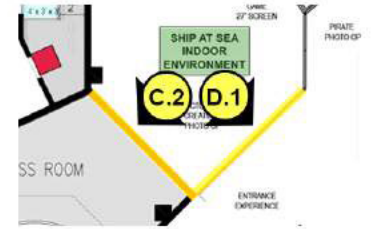

KEY ELEVATION  
SCALE: NOT TO SCALE

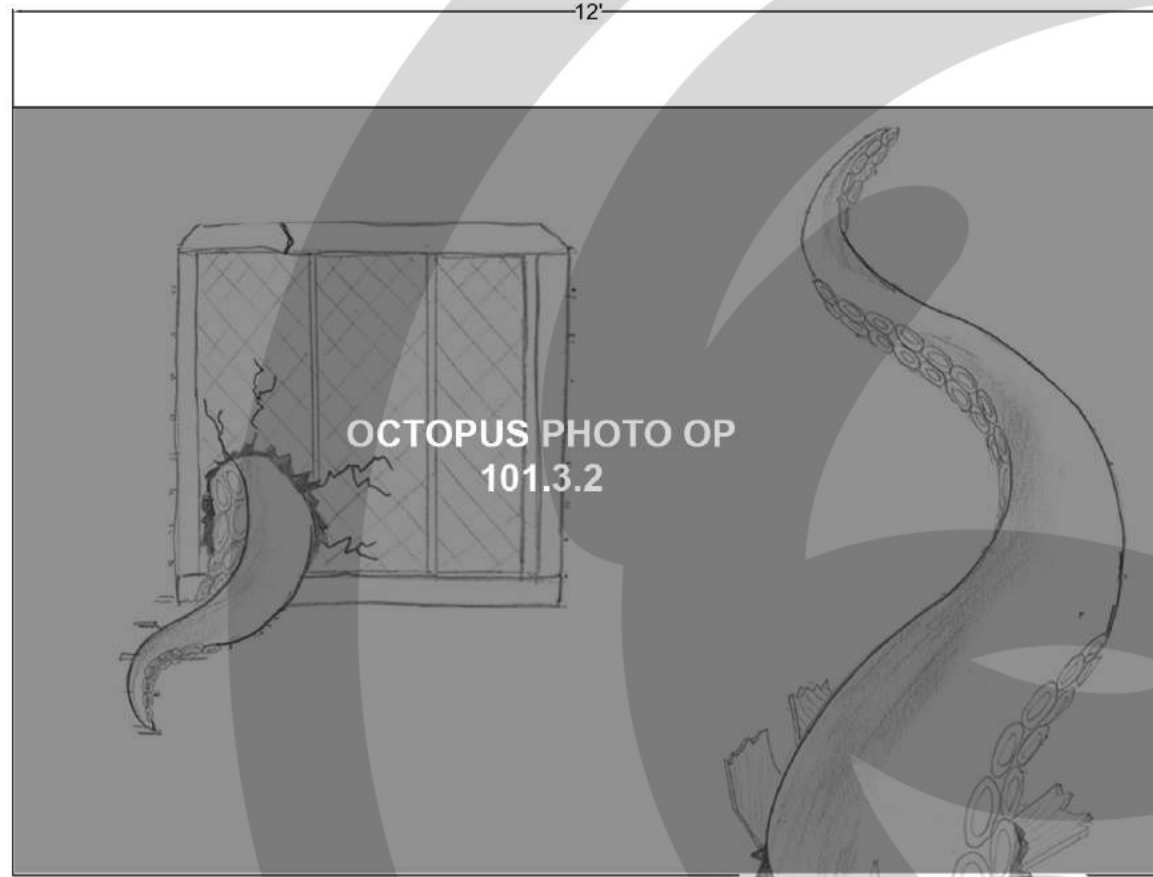

ELEVATION D.1

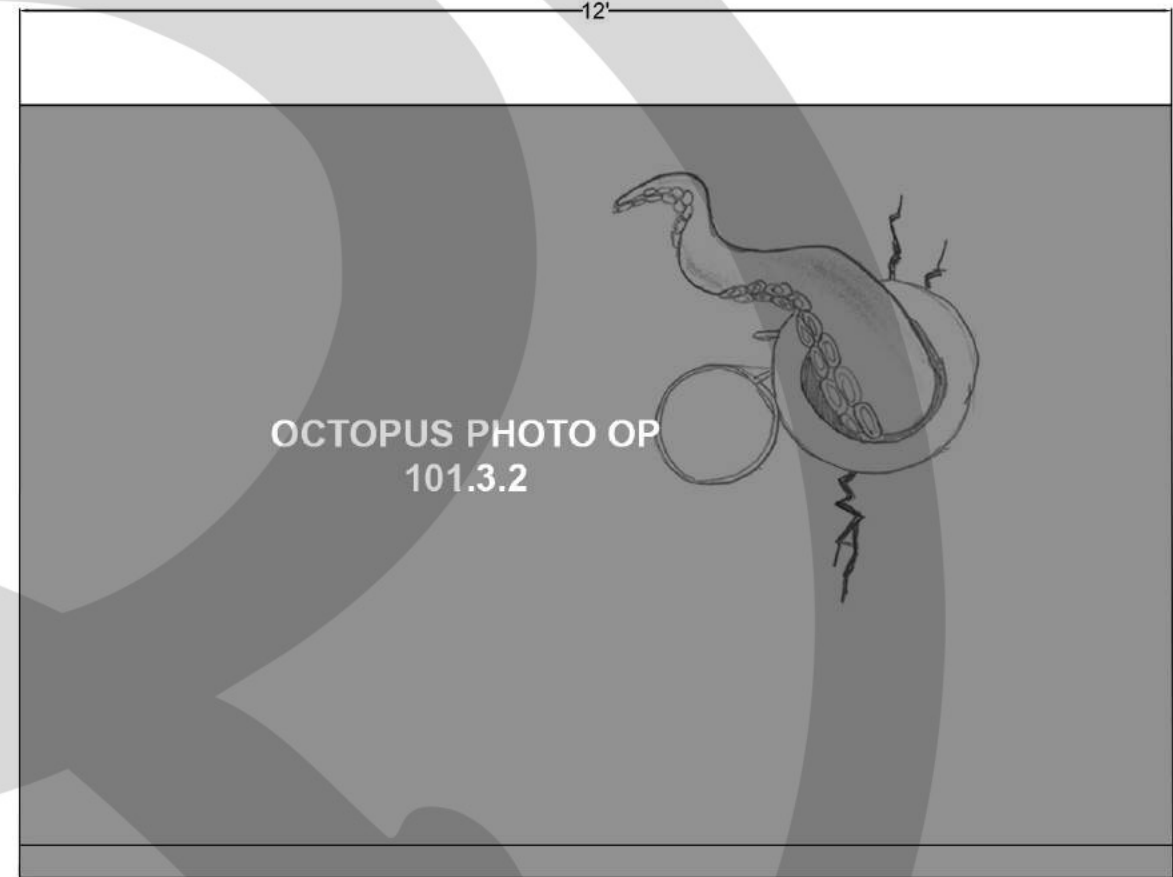

ELEVATION C.2

TM

10 SHIP INDOOR-ELEVATION C.2-D.1  
SCALE: 1/2" = 1'

**RIPLEY**  
ENTERTAINMENT, INC.  
7576 KINGSPOINTE PKWY #188  
ORLANDO, FLORIDA 32819  
(407).345.8010  
  
WWW.RIPLEYS.COM

PROJECT LOCATION:  
**GATLINBURG, TN**  
  
NOTES:

PROJECT TITLE:  
  
**Ripley's AQUARIUMS**

DATE:  
**2/19**  
REVISED DATE:  
  
SCALE: 1/2" = 1'

DRAWN BY:  
**CCOYLE**  
  
APPROVED BY:

SHEET #  
  
101.2.6  
SHIP INDOOR  
ELEVATION  
C.2-D.1





EXHIBIT REFERENCE



E-2 [EXHIBIT-2] EXHIBIT #17527 BAYONET PISTOL  
NOTE: Move exhibit case from Shipwrecks gallery to here.



EXHIBIT CASE B

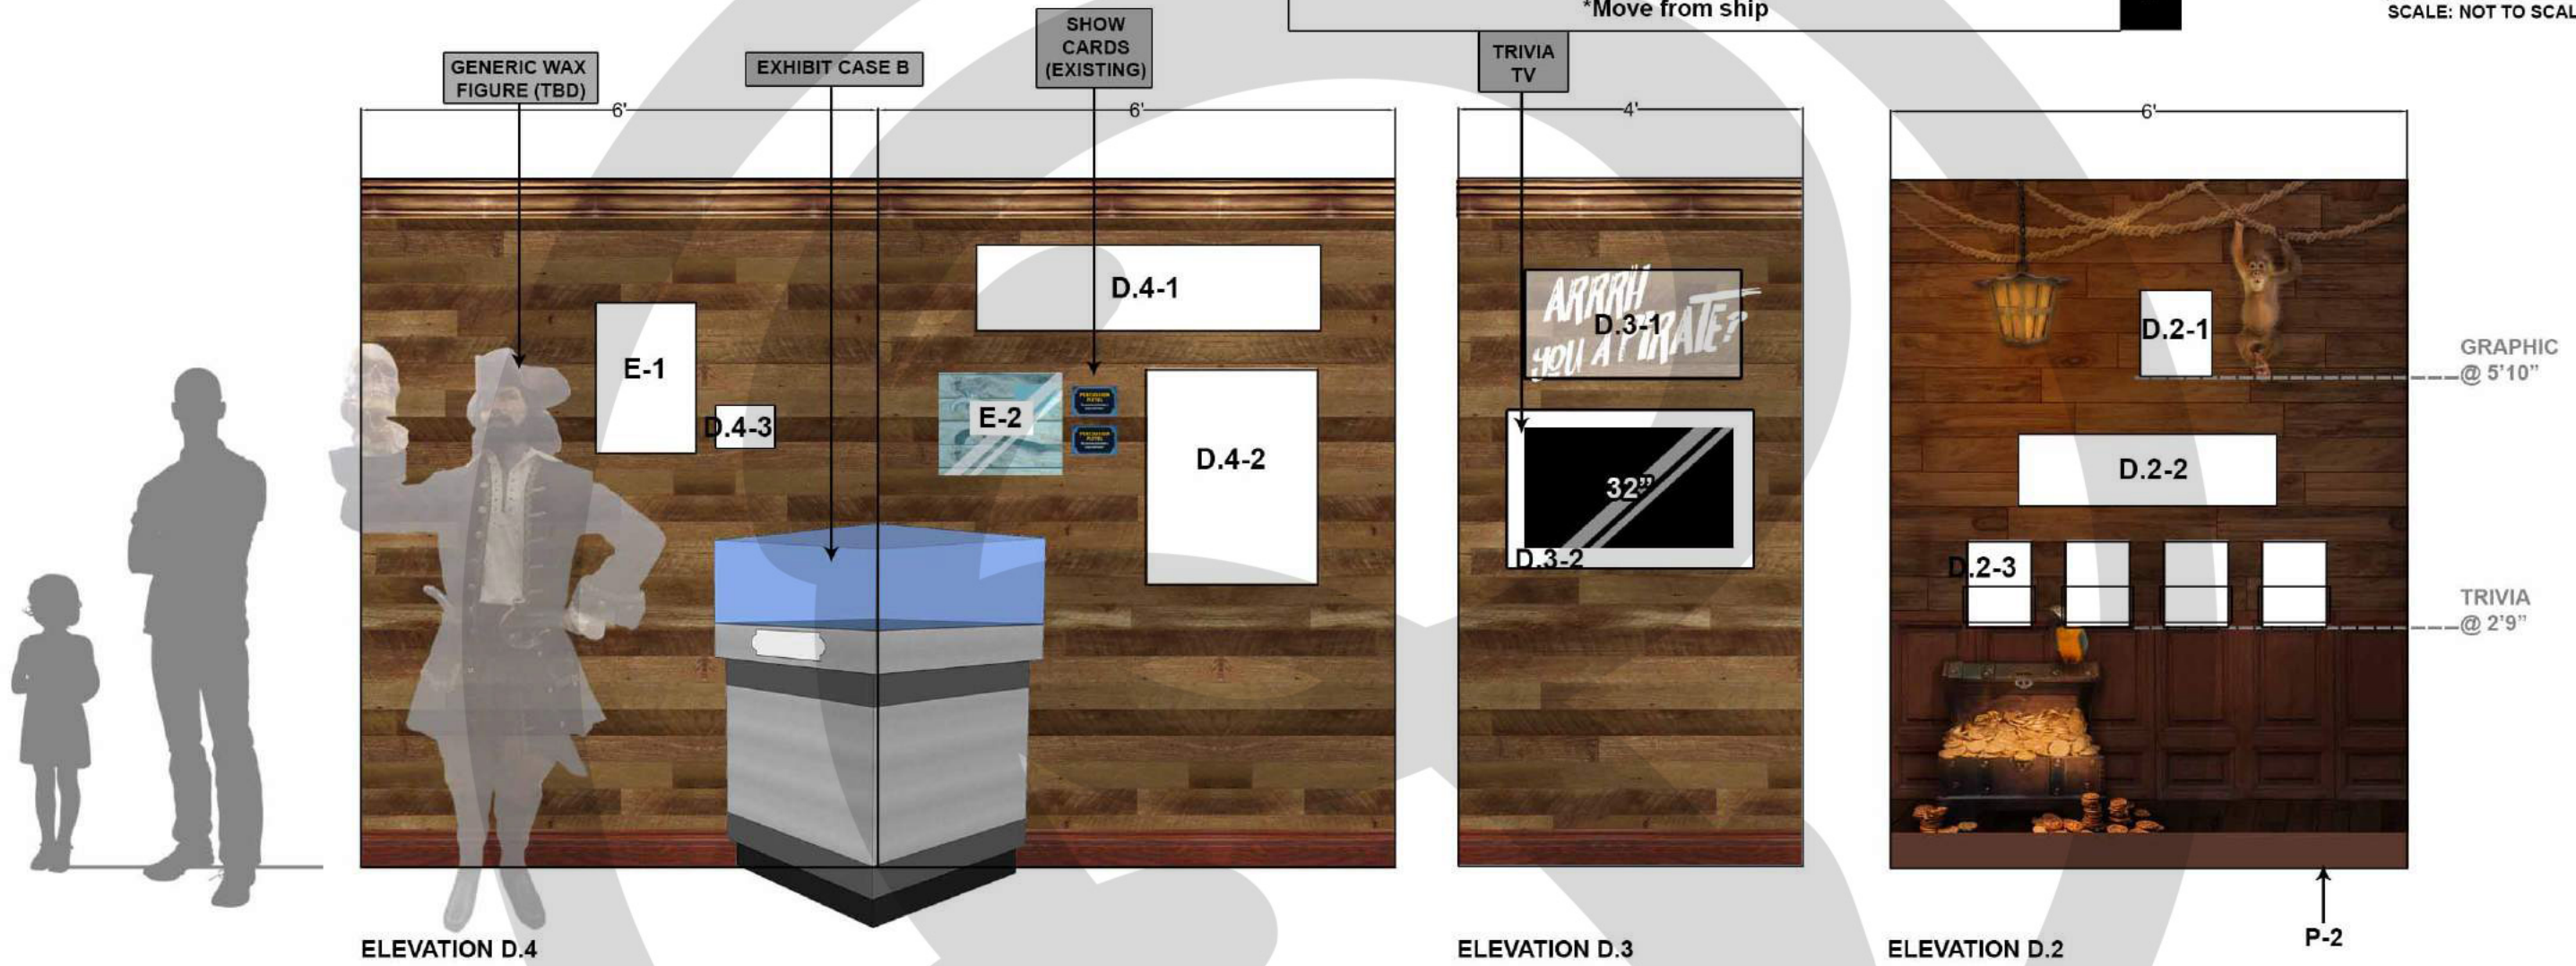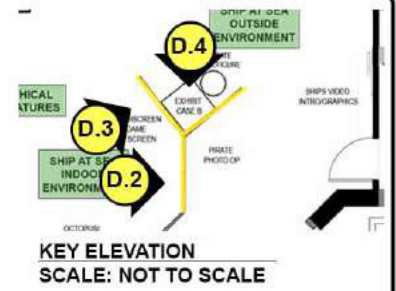

PAINT REFERENCE

P-2 [PAINT 2] TERRA BRUN SW 6048 SATIN sherwin-williams.com



11 SHIP INDOOR-ELEVATION D.2-D.4 SCALE: 1/2" = 1'

RIPLY ENTERTAINMENT, INC. 7576 KINGSPOINTE PKWY #188 ORLANDO, FLORIDA 32819 (407).345.8010 WWW.RIPLEYS.COM



PROJECT LOCATION: GATLINBURG, TN NOTES:

PROJECT TITLE: Ripley's AQUARIUMS

DATE: 2/19 REVISED DATE: SCALE: 1/2" = 1'

DRAWN BY: CCOYLE APPROVED BY:

SHEET # 101.2.7 SHIP INDOOR ELEVATION D.2 - D.4

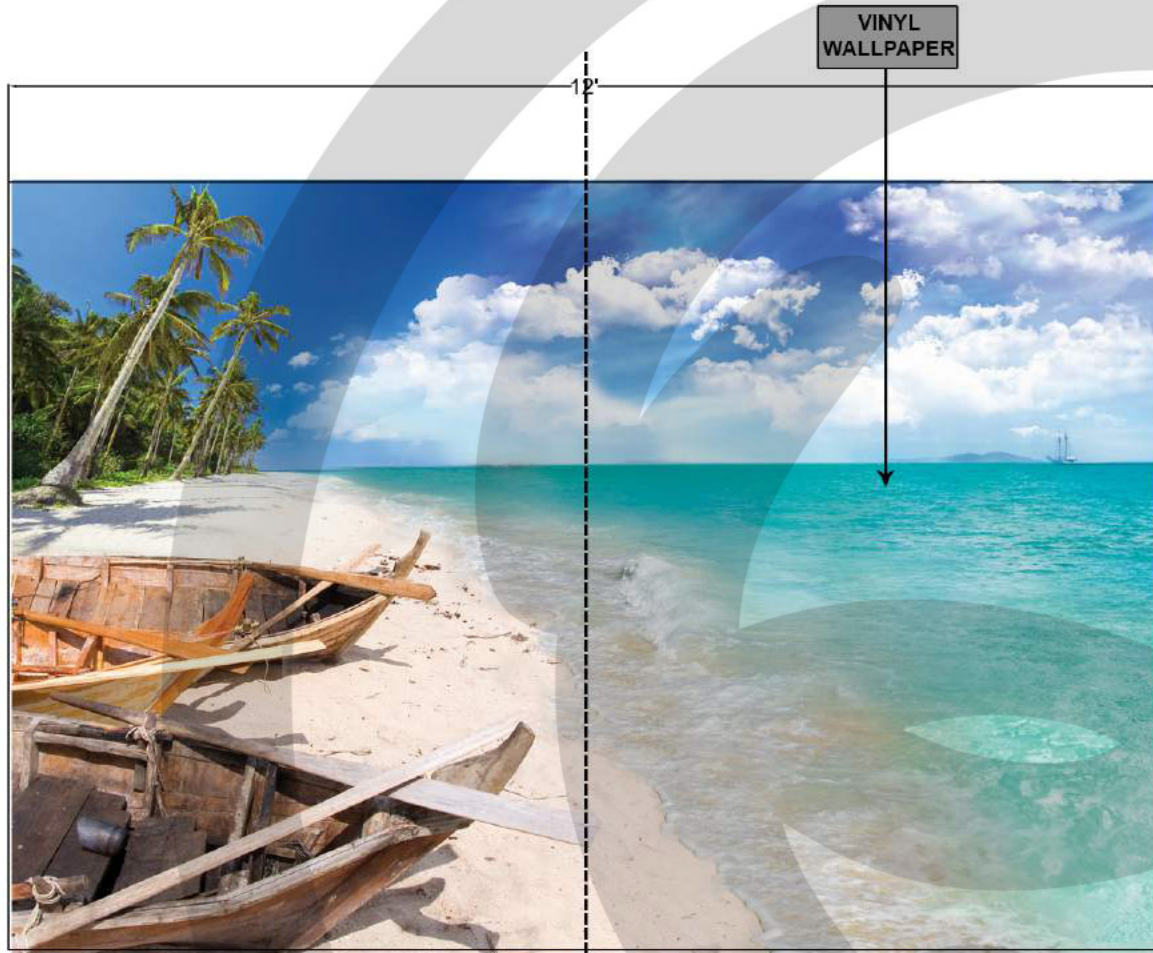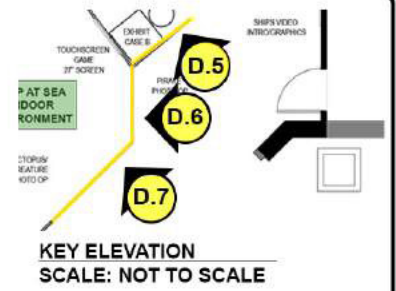


6' PANEL  
ELEVATION D.7



6' PANEL



ELEVATION D.6

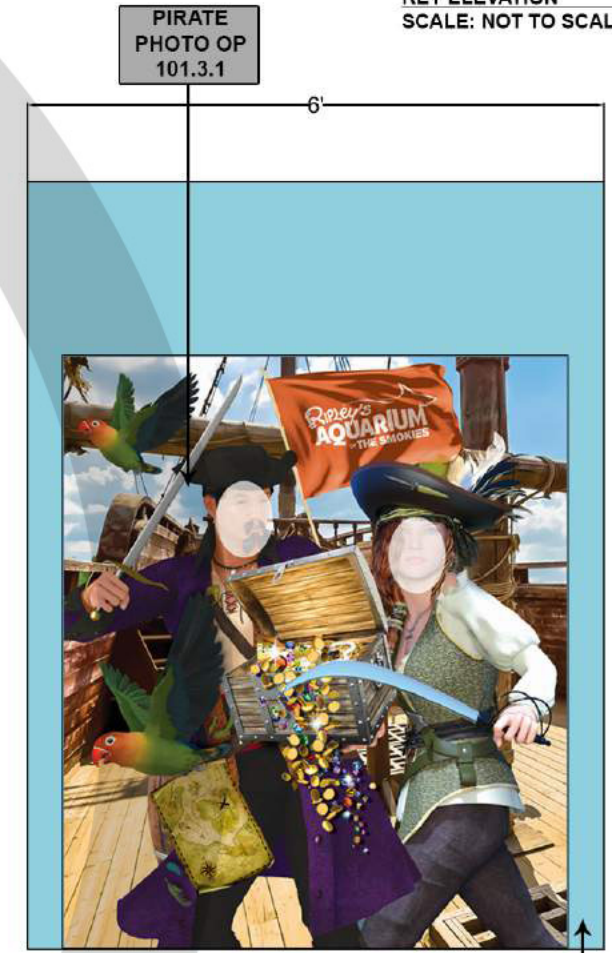

ELEVATION D.5

PAINT REFERENCE

**P-1 [PAINT 1]**  
**CLOUDLESS**  
 SW 6786  
 SATIN  
 sherwin-williams.com

**13** SHIP INDOOR-ELEVATION D.5-D.7  
 SCALE: 1/2" = 1'

**RIPLEY**  
 ENTERTAINMENT, INC.  
 7576 KINGSPOINTE PKWY #188  
 ORLANDO, FLORIDA 32819  
 (407).345.8010  
 WWW.RIPLEYS.COM

PROJECT LOCATION:  
**GATLINBURG, TN**  
 NOTES:

PROJECT TITLE:  



DATE:  
**2/19**  
 REVISED DATE:  
 SCALE: 1/2" = 1'

DRAWN BY:  
**CCOYLE**  
 APPROVED BY:


SHEET #  
 101.2.8  
 SHIP DECK  
 ELEVATION  
 D.5-D.7



EXHIBIT REFERENCE

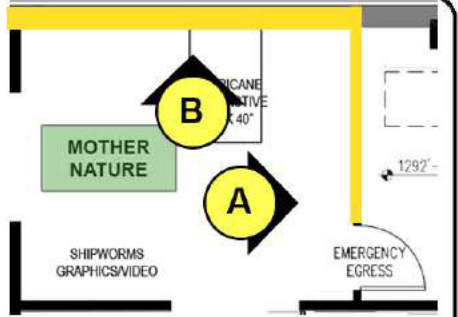

KEY ELEVATION SCALE: NOT TO SCALE

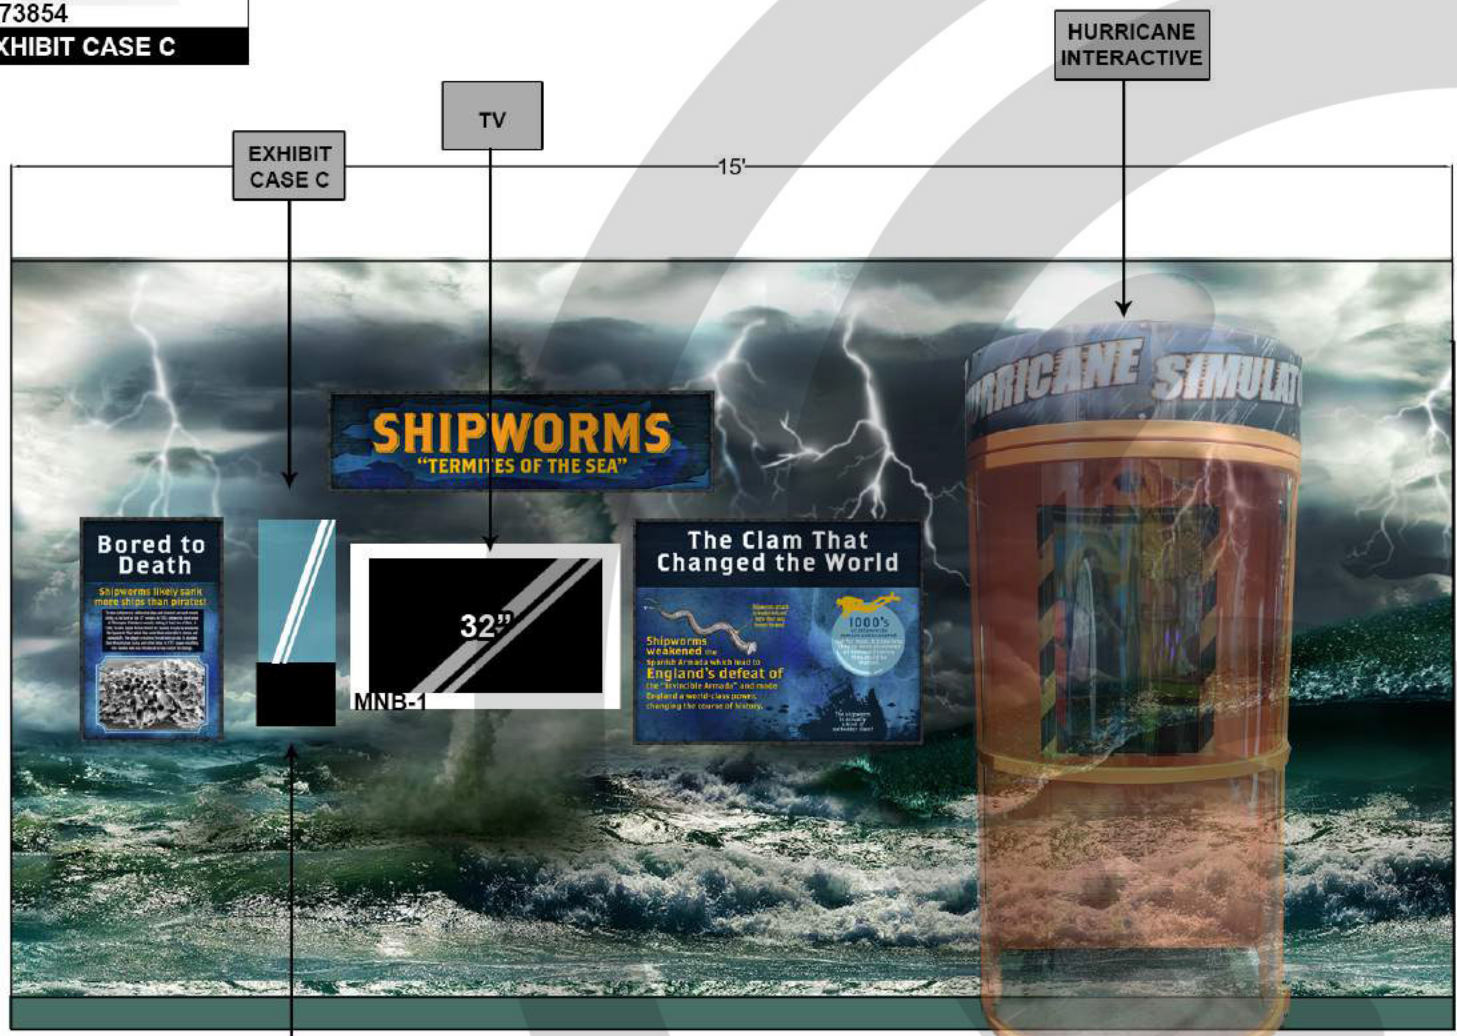

ELEVATION B SHOWCARD INSIDE CASE MNB-2



ELEVATION A P-3 TM

PAINT REFERENCE

P-3 [PAINT 3] RAGING SEA SW 6474 SATIN sherwin-williams.com

13 MOTHER NATURE -ELEVATION A-B SCALE: 1/2" = 1'

RIPLY ENTERTAINMENT, INC. 7576 KINGSPONTE PKWY #188 ORLANDO, FLORIDA 32819 (407).345.8010 WWW.RIPLEYS.COM

PROJECT LOCATION: GATLINBURG, TN NOTES:

PROJECT TITLE: Ripley's AQUARIUMS

DATE: 2/19 REVISED DATE: SCALE: 1/2" = 1'

DRAWN BY: CCOYLE APPROVED BY:


SHEET # 101.2.9 MOTHER NATURE ELEVATION A-B




**EXHIBIT REFERENCE**



#10476  
EXHIBIT CASE D

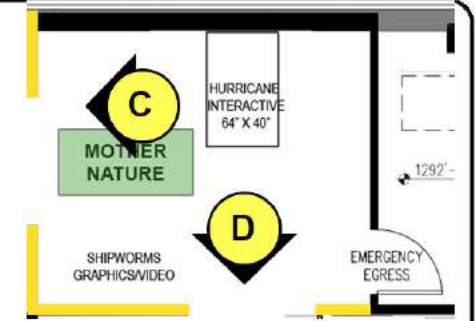

KEY ELEVATION  
SCALE: NOT TO SCALE

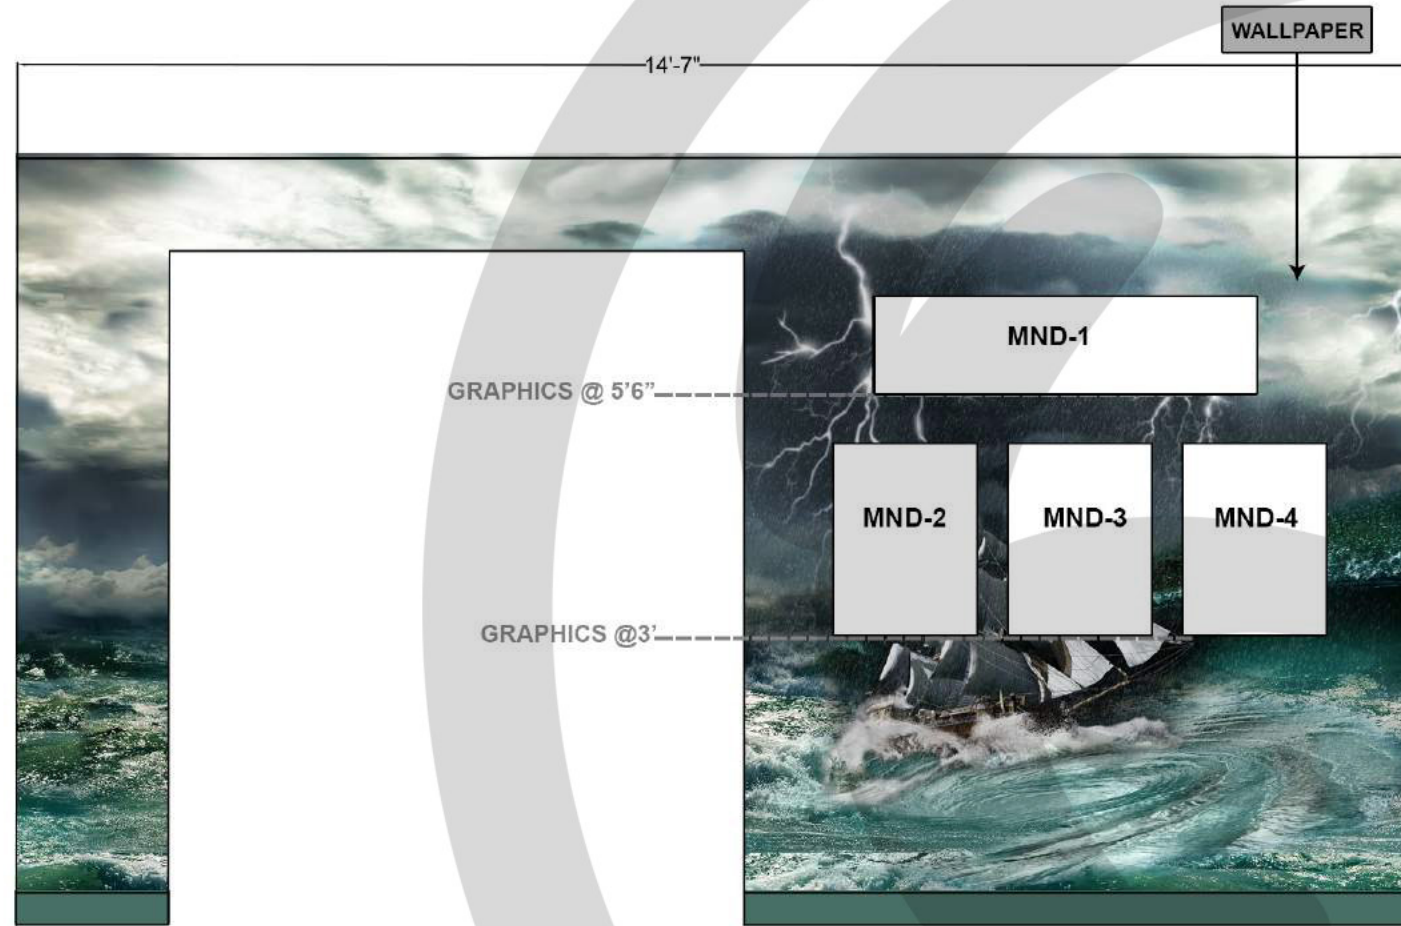

ELEVATION D



ELEVATION C

TM

**PAINT REFERENCE**

	<p>P-1 [PAINT 1] RAGING SEA SW 6474 SATIN sherwin-williams.com</p>
--	--

14 MOTHER NATURE-ELEVATION C & D  
SCALE: 1/2" = 1'

**RIPLEY**  
ENTERTAINMENT, INC.  
7576 KINGSPOINTE PKWY #188  
ORLANDO, FLORIDA 32819  
(407).345.8010  
  
WWW.RIPLEYS.COM

PROJECT LOCATION:  
**GATLINBURG, TN**

NOTES:

PROJECT TITLE:



DATE:  
**2/19**

REVISED DATE:

SCALE: 1/2" = 1'

DRAWN BY:  
**CCOYLE**

APPROVED BY:

SHEET #

101.2.10  
MOTHER NATURE  
ELEVATION C-D



**NOTES**

**NOTE:**  
WALLPAPER IS SEAMLESS



#21566




#15116

**EXHIBIT CASE A**



**8"w Wall Wedge Display Case- Black**  
SKU: DCWWDG8BK  
\$75.99  
DIM: 8.0" x 26.0" x 12.0"  
www.displays2go.com

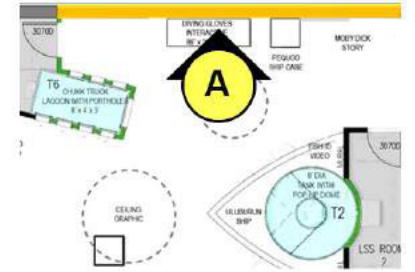

**KEY ELEVATION**  
SCALE: NOT TO SCALE

UNDERWATER WALLPAPER

DIVER INTERACTIVE

SHIP CASE 101.3.2

MOBY DICK GRAPHICS

TITLE CARD

MOBY DICK VIDEO

EXHIBIT BOX A DETAILS: TBD

HARPOON EXHIBIT

34'-5"

15'-2"

11'



CUT GRAPHIC FOR SUBMARINE INTERACTIVE

TITLE CARD @ 6'5"

GRAPHIC @ 5'1"

GRAPHIC @ 4'

VIDEO @ 3'6"

GRAPHICS @ 3'1"

CONTINUED ON NEXT PAGE

**P-5 [PAINT 5]**  
SECURE BLUE  
SW 6508  
SATIN  
sherwin-williams.com

**F-1 [FINISH 1]**  
FLEXCO Vinyl Wall Base  
BLACK  
Item # 378981  
lowes.com

**15** SHIPWRECKS-ELEVATION A  
SCALE: 1/2" = 1'

**RIPLEY**  
ENTERTAINMENT, INC.  
7576 KINGSPONTE PKWY #188  
ORLANDO, FLORIDA 32819  
(407).345.8010  
  
WWW.RIPLEYS.COM

PROJECT LOCATION:  
**GATLINBURG, TN**  
  
NOTES:


PROJECT TITLE:

DATE:  
**2/19**  
REVISED DATE:  
  
SCALE: 1/2" = 1'


DRAWN BY:  
**CCOYLE**  
  
APPROVED BY:

SHEET #  
  
101.2.11  
SHIPWRECKS  
ELEVATION A




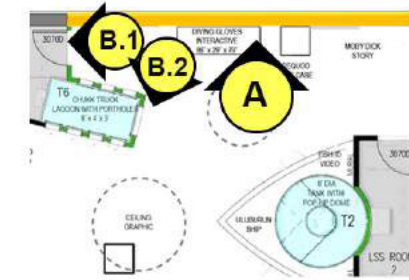


KEY ELEVATION  
SCALE: NOT TO SCALE

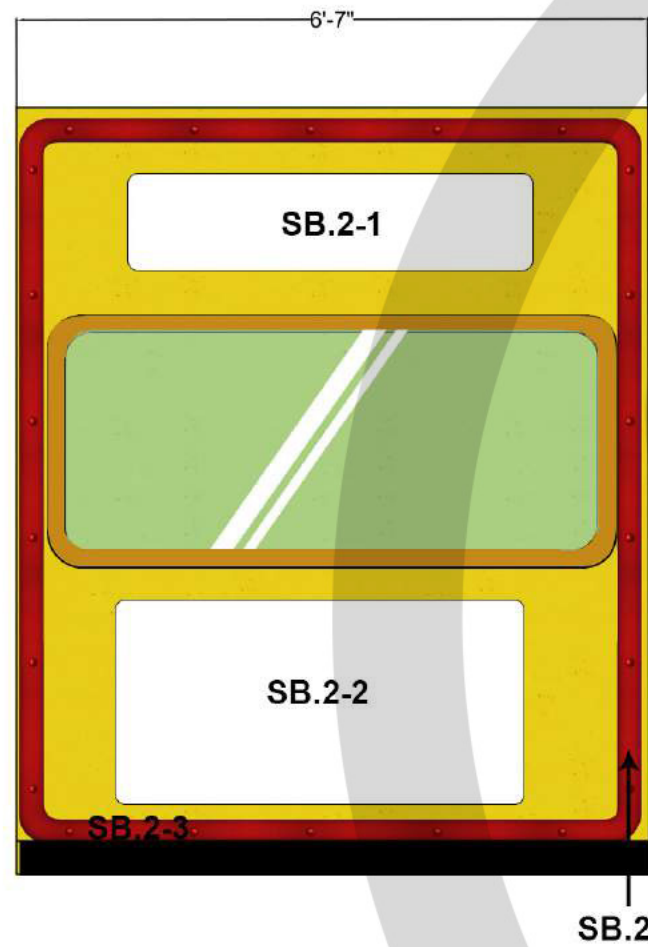

ELEVATION B.2

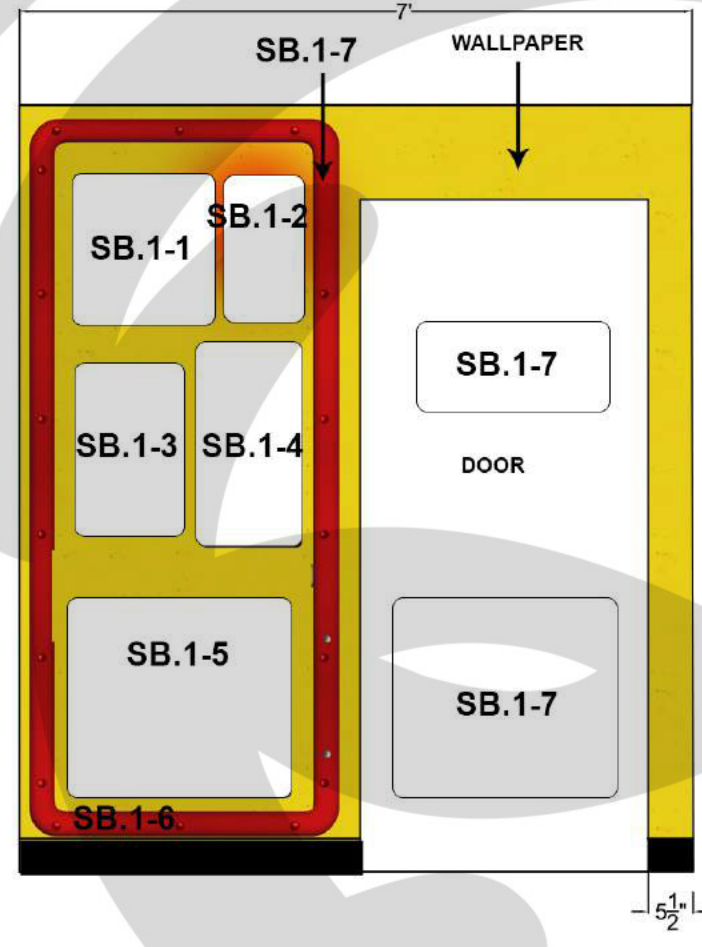

ELEVATION B.1

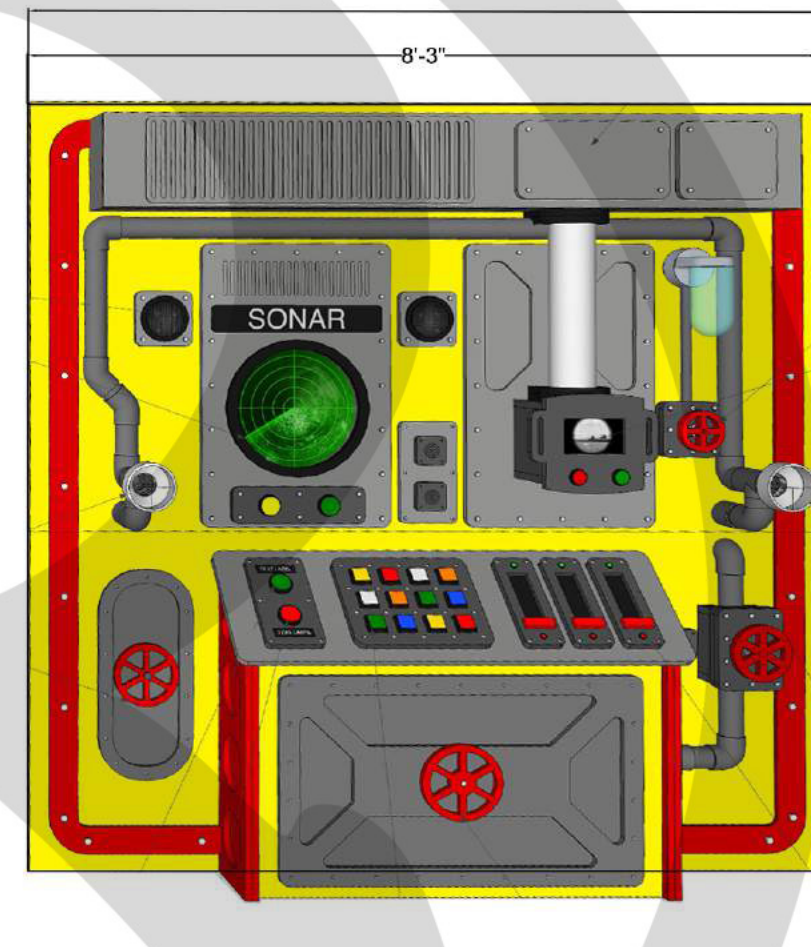

ELEVATION A (CONTINUED)

TM

16 SHIPWRECKS-ELEVATION A-B.2  
SCALE: 1/2" = 1'

**RIPLEY**  
ENTERTAINMENT, INC.  
7576 KINGSPOINTE PKWY #188  
ORLANDO, FLORIDA 32819  
(407).345.8010  
  
WWW.RIPLEYS.COM


PROJECT LOCATION:  
**GATLINBURG, TN**  
  
NOTES:

PROJECT TITLE:

DATE:  
**2/19**  
REVISED DATE:  
  
SCALE:


DRAWN BY:  
**CCOYLE**  
  
APPROVED BY:

SHEET #  
  
101.2.12  
SHIPWRECKS  
ELEVATION A-  
B.2

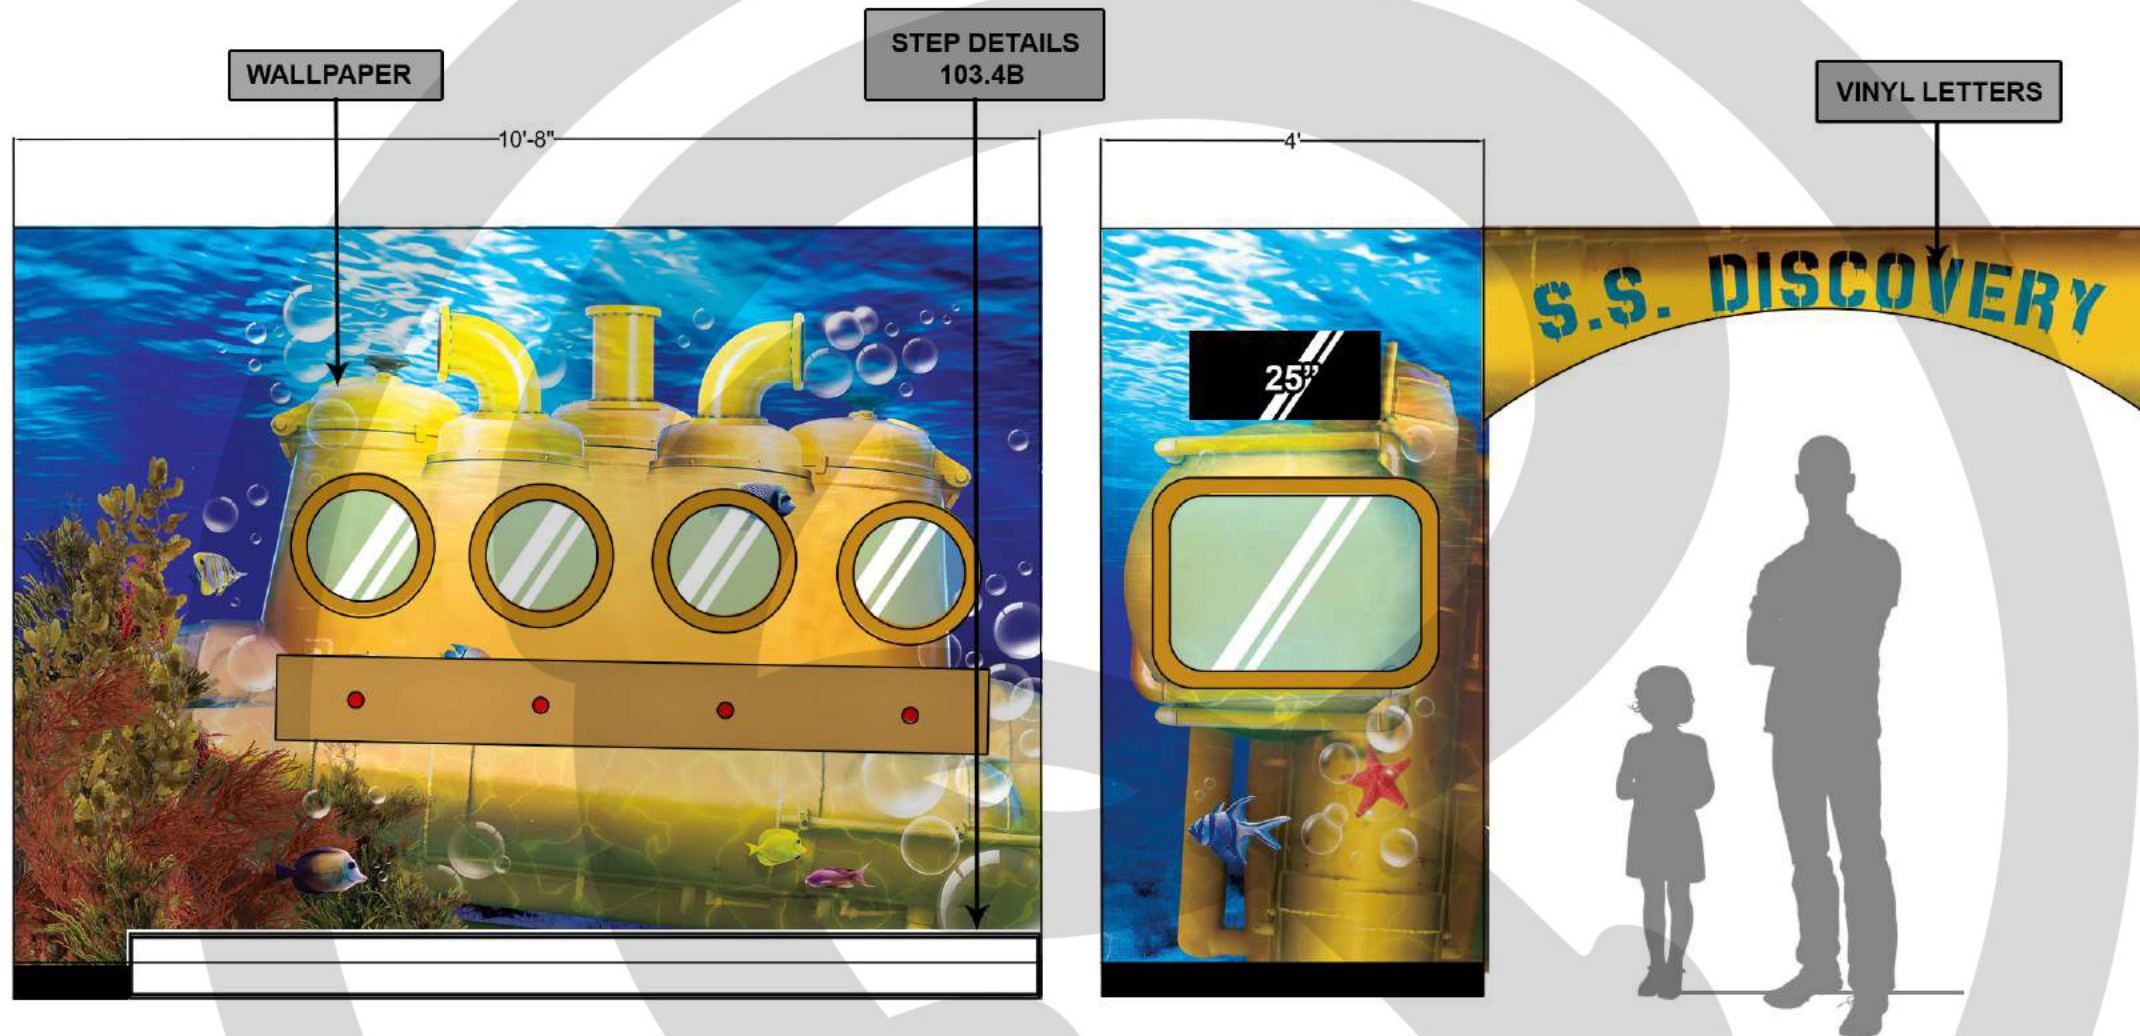

ELEVATION B.4

ELEVATION B.3

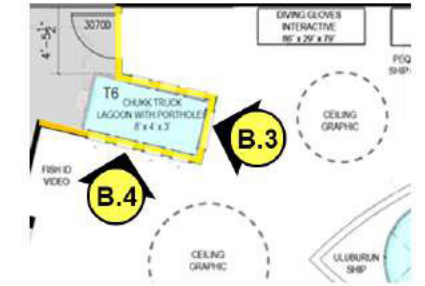

KEY ELEVATION  
SCALE: NOT TO SCALE

17 SHIPWRECKS-ELEVATION B.1 -B.4  
SCALE: 1/2" = 1'

**RIPLEY**  
ENTERTAINMENT, INC.  
7576 KINGSPOINTE PKWY #188  
ORLANDO, FLORIDA 32819  
(407).345.8010  
  
WWW.RIPLEYS.COM

PROJECT LOCATION:  
**GATLINBURG, TN**  
  
NOTES:

PROJECT TITLE:  
  
**Ripley's  
AQUARIUMS**

DATE:  
**2/19**  
REVISED DATE:  
  
SCALE: 1/2" = 1'

DRAWN BY:  
**CCOYLE**  
  
APPROVED BY:

SHEET #  
  
101.2.13  
SW  
ELEVATION  
B.3-B.4



**PARTS REFERENCE**





**Aluminum J-Cap - 1/4" Face for 3/32" Material**  
Part#: E-82  
QTY: 2  
eagle-aluminum.com



**CLEAR GLASSLESS MIRROR**  
48"W X 92"H  
dullesglassandmirror.com

**NOTES**

- CAN ORDER MIRROR ON SITE AND APPLY.
- USE J-CAP TO ATTACH MIRROR TO WALL

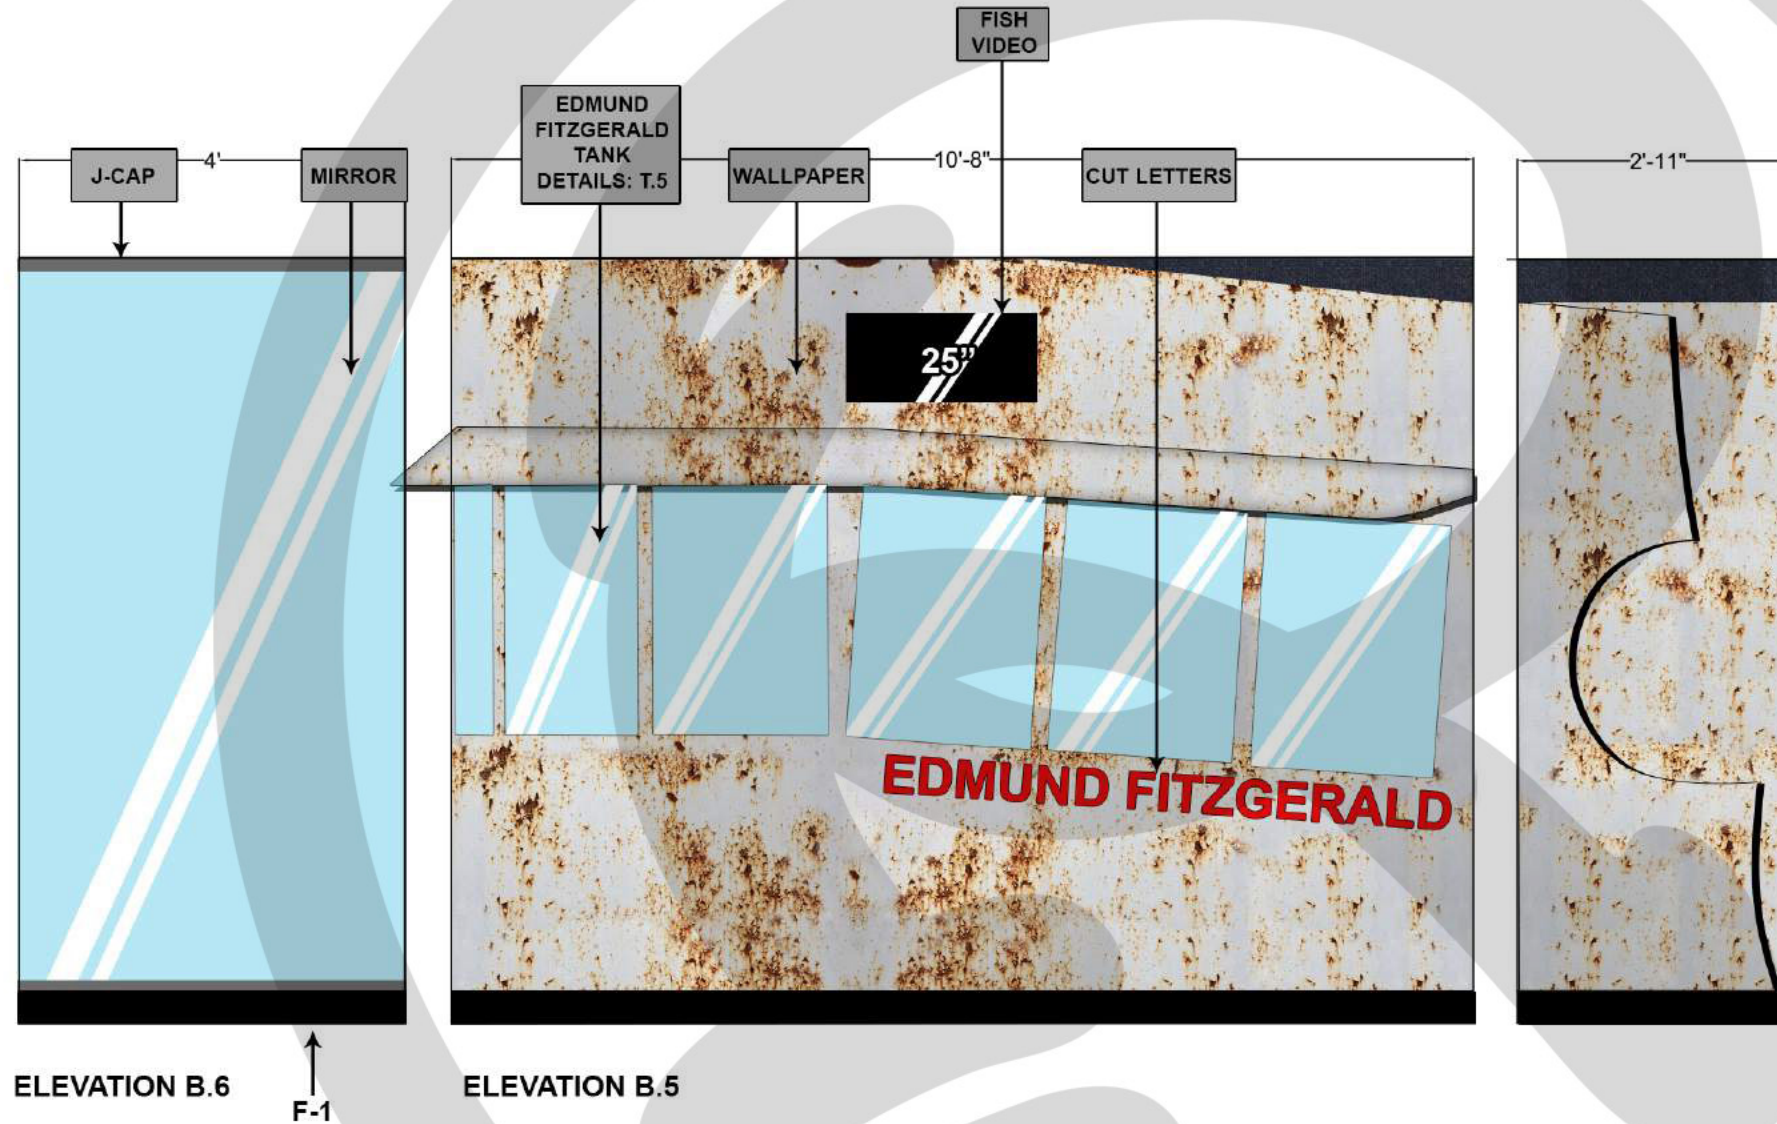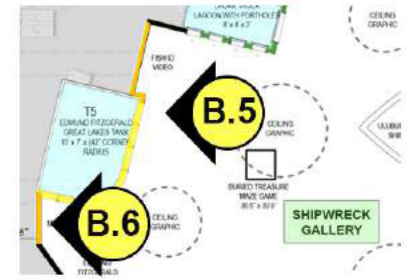

**FINISH REFERENCE**



WC-2 [WALL-CARPET 2]  
00403 INK  
nationalwallcovering.com

18 SHIPWRECKS-ELEVATION B.5, B.6  
SCALE: 1/2" = 1'

**RIPLEY**  
ENTERTAINMENT, INC.  
7576 KINGSPOINTE PKWY #188  
ORLANDO, FLORIDA 32819  
(407).345.8010  
  
WWW.RIPLEYS.COM


PROJECT LOCATION:  
**GATLINBURG, TN**  
  
NOTES:

PROJECT TITLE:


DATE:  
**2/19**  
REVISED DATE:  
  
SCALE: 1/2" = 1'

DRAWN BY:  
**CCOYLE**  
  
APPROVED BY:

SHEET #  
  
101.2.14  
SW  
ELEVATION  
B.5 & B.6

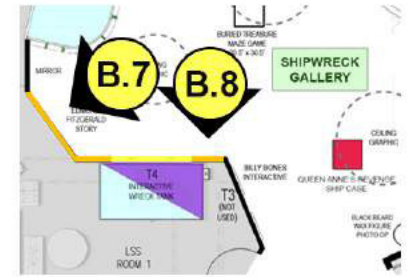

KEY ELEVATION  
SCALE: NOT TO SCALE

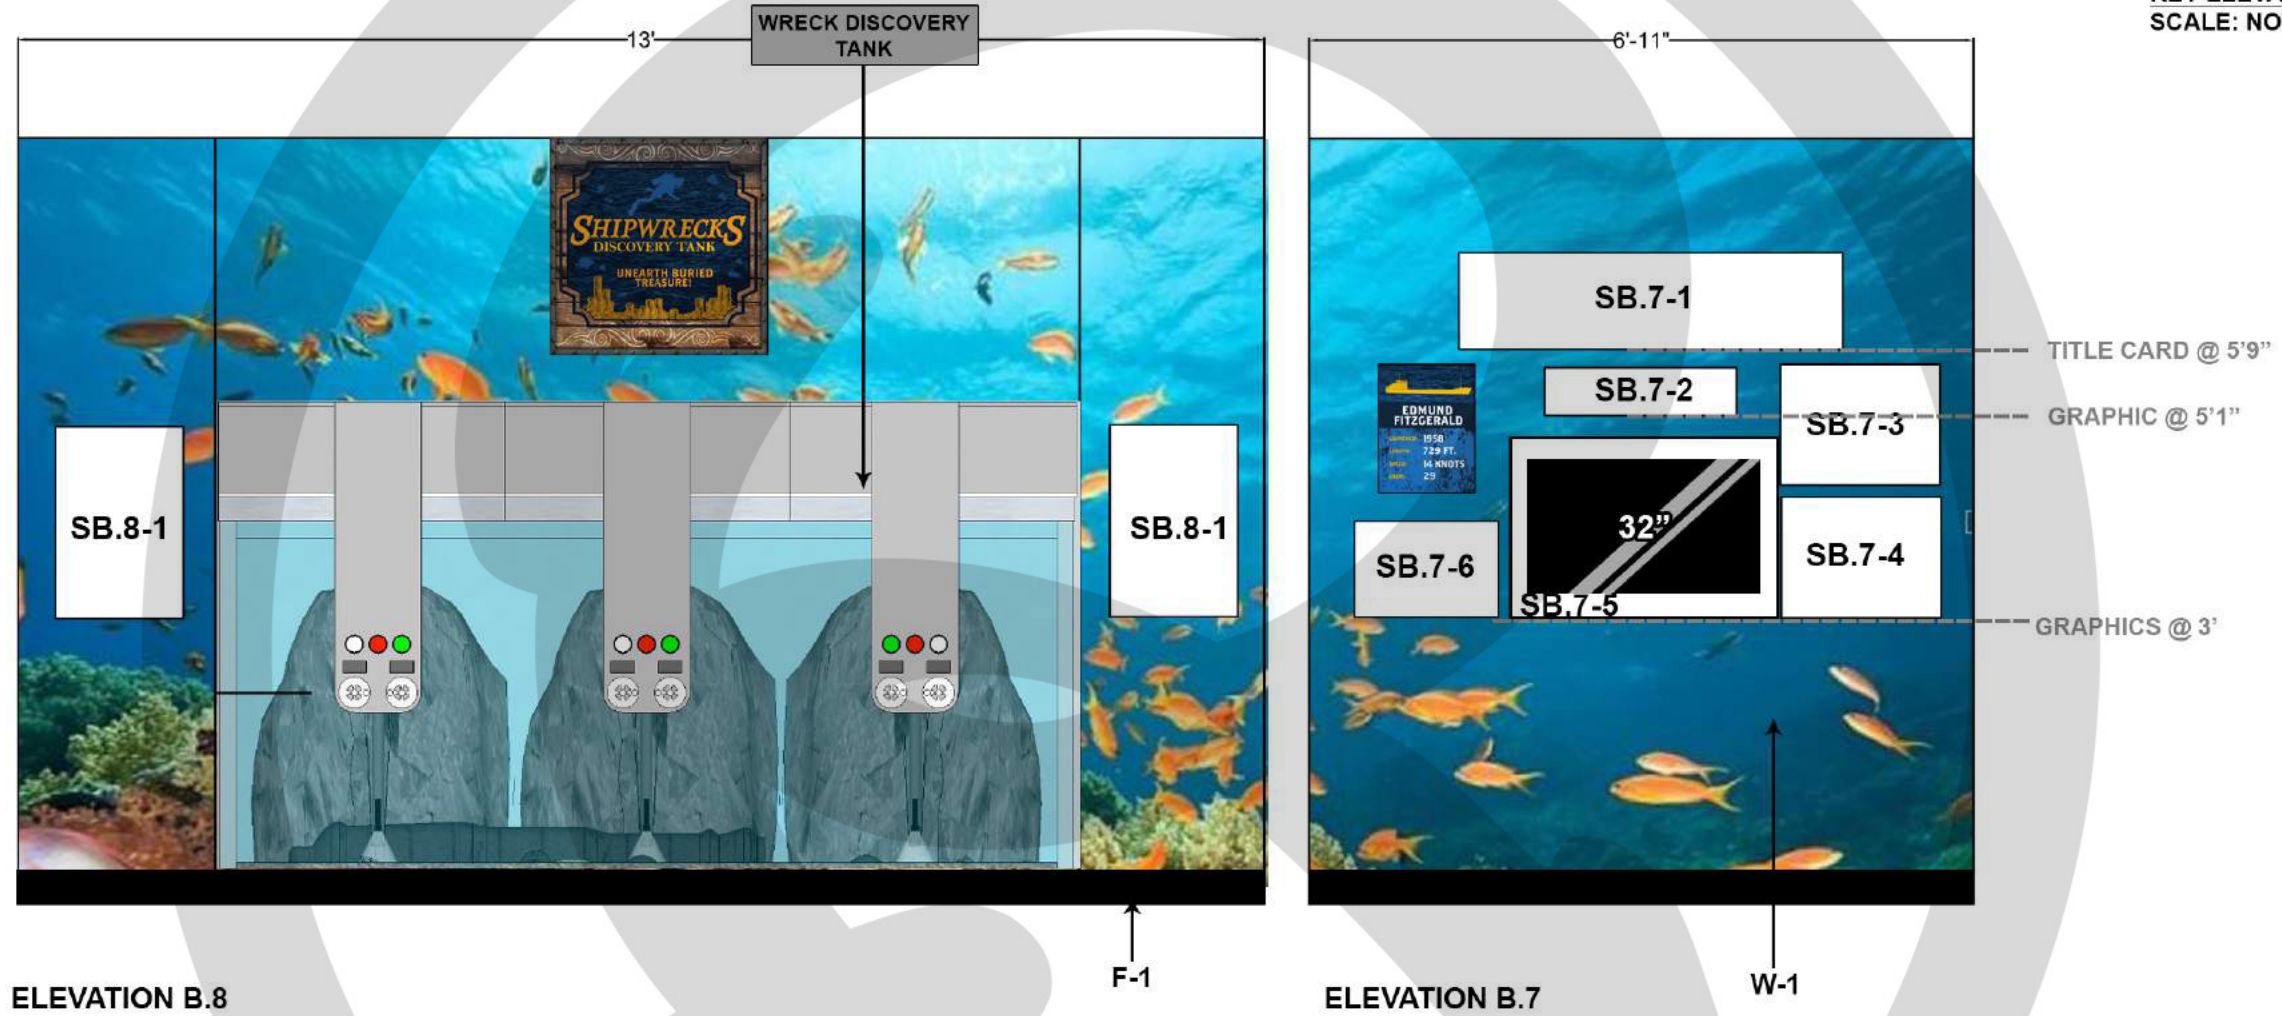

FINISH REFERENCE

F-1 [FINISH 1]  
FLEXCO Vinyl Wall Base  
BLACK  
Item # 378981  
lowes.com

WALLPAPER REFERENCE

W-1 [WALLPAPER 1]  
ID: FOT-0013547175  
www.magicmurals.com

19 SHIPWRECKS-ELEVATION B.7, B.8  
SCALE: 1/2" = 1'

**RIPLEY**  
ENTERTAINMENT, INC.  
7576 KINGSPOINTE PKWY #188  
ORLANDO, FLORIDA 32819  
(407).345.8010

WWW.RIPLEYS.COM

PROJECT LOCATION:  
**GATLINBURG, TN**

NOTES:


PROJECT TITLE:






DATE:  
**2/19**  
REVISED DATE:  
SCALE: 1/2" = 1'

DRAWN BY:  
**CCOYLE**  
APPROVED BY:

SHEET #  
101.2.15  
SW  
ELEVATION  
B.7 & B.8

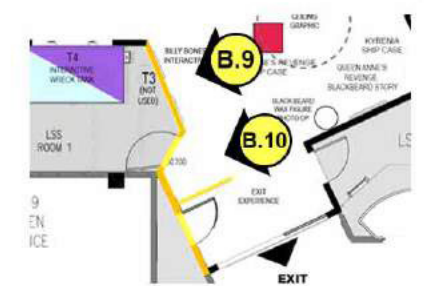

KEY ELEVATION  
SCALE: NOT TO SCALE

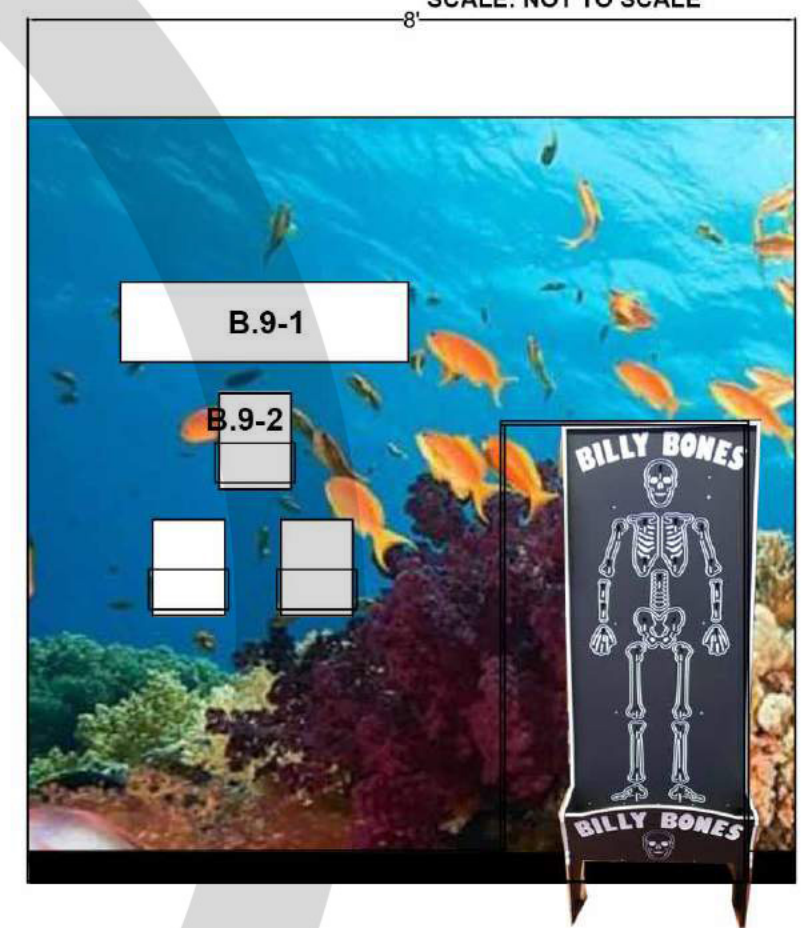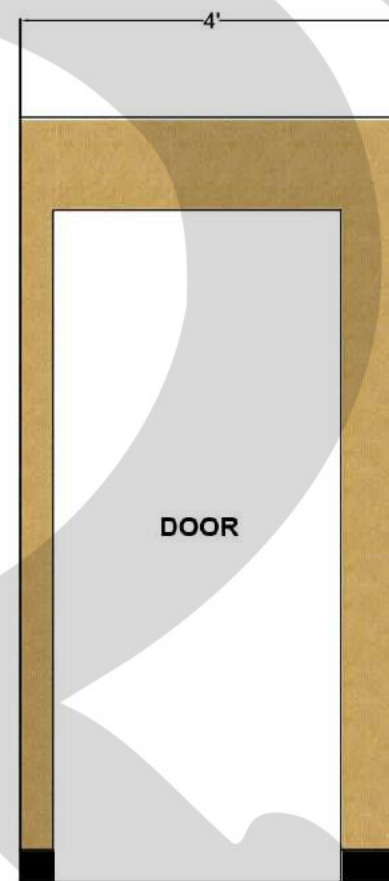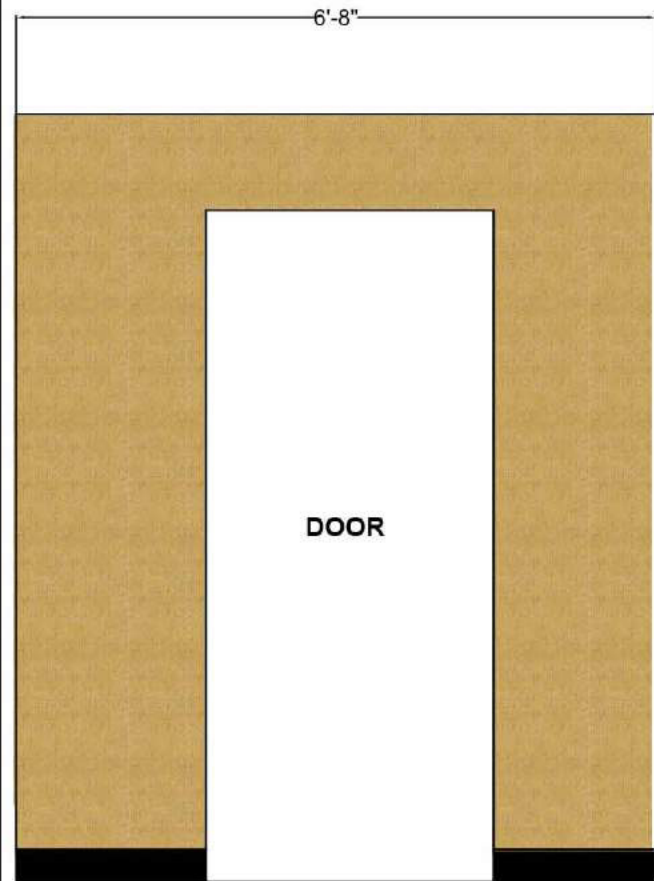

ELEVATION B.10

ELEVATION B.9

TM

 **F-1 [FINISH 1]**  
**FLEXCO Vinyl Wall Base**  
BLACK  
Item # 378981  
lowes.com

 **WC-1 [WALL-CARPET 1]**  
**00201 DEL SOL**  
nationalwallcovering.com

**20** SHIPWRECKS-ELEVATION B.9, B.10  
SCALE: 1/2" = 1'

**RIPLEY**  
ENTERTAINMENT, INC.  
7576 KINGSPONTE PKWY #188  
ORLANDO, FLORIDA 32819  
(407).345.8010  
  
WWW.RIPLEYS.COM


PROJECT LOCATION:  
**GATLINBURG, TN**  
  
NOTES:

PROJECT TITLE:  



DATE:  
**2/19**  
REVISED DATE:  
  
SCALE: 1/2" = 1'

DRAWN BY:  
**CCOYLE**  
  
APPROVED BY:

SHEET #  
  
101.2.16  
SW  
ELEVATION  
B.9 & B.10

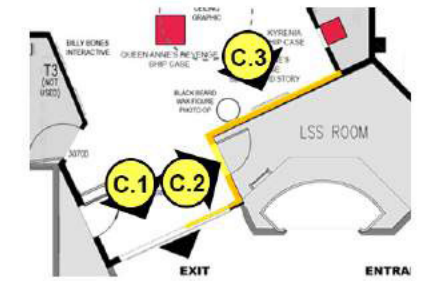

KEY ELEVATION  
SCALE: NOT TO SCALE

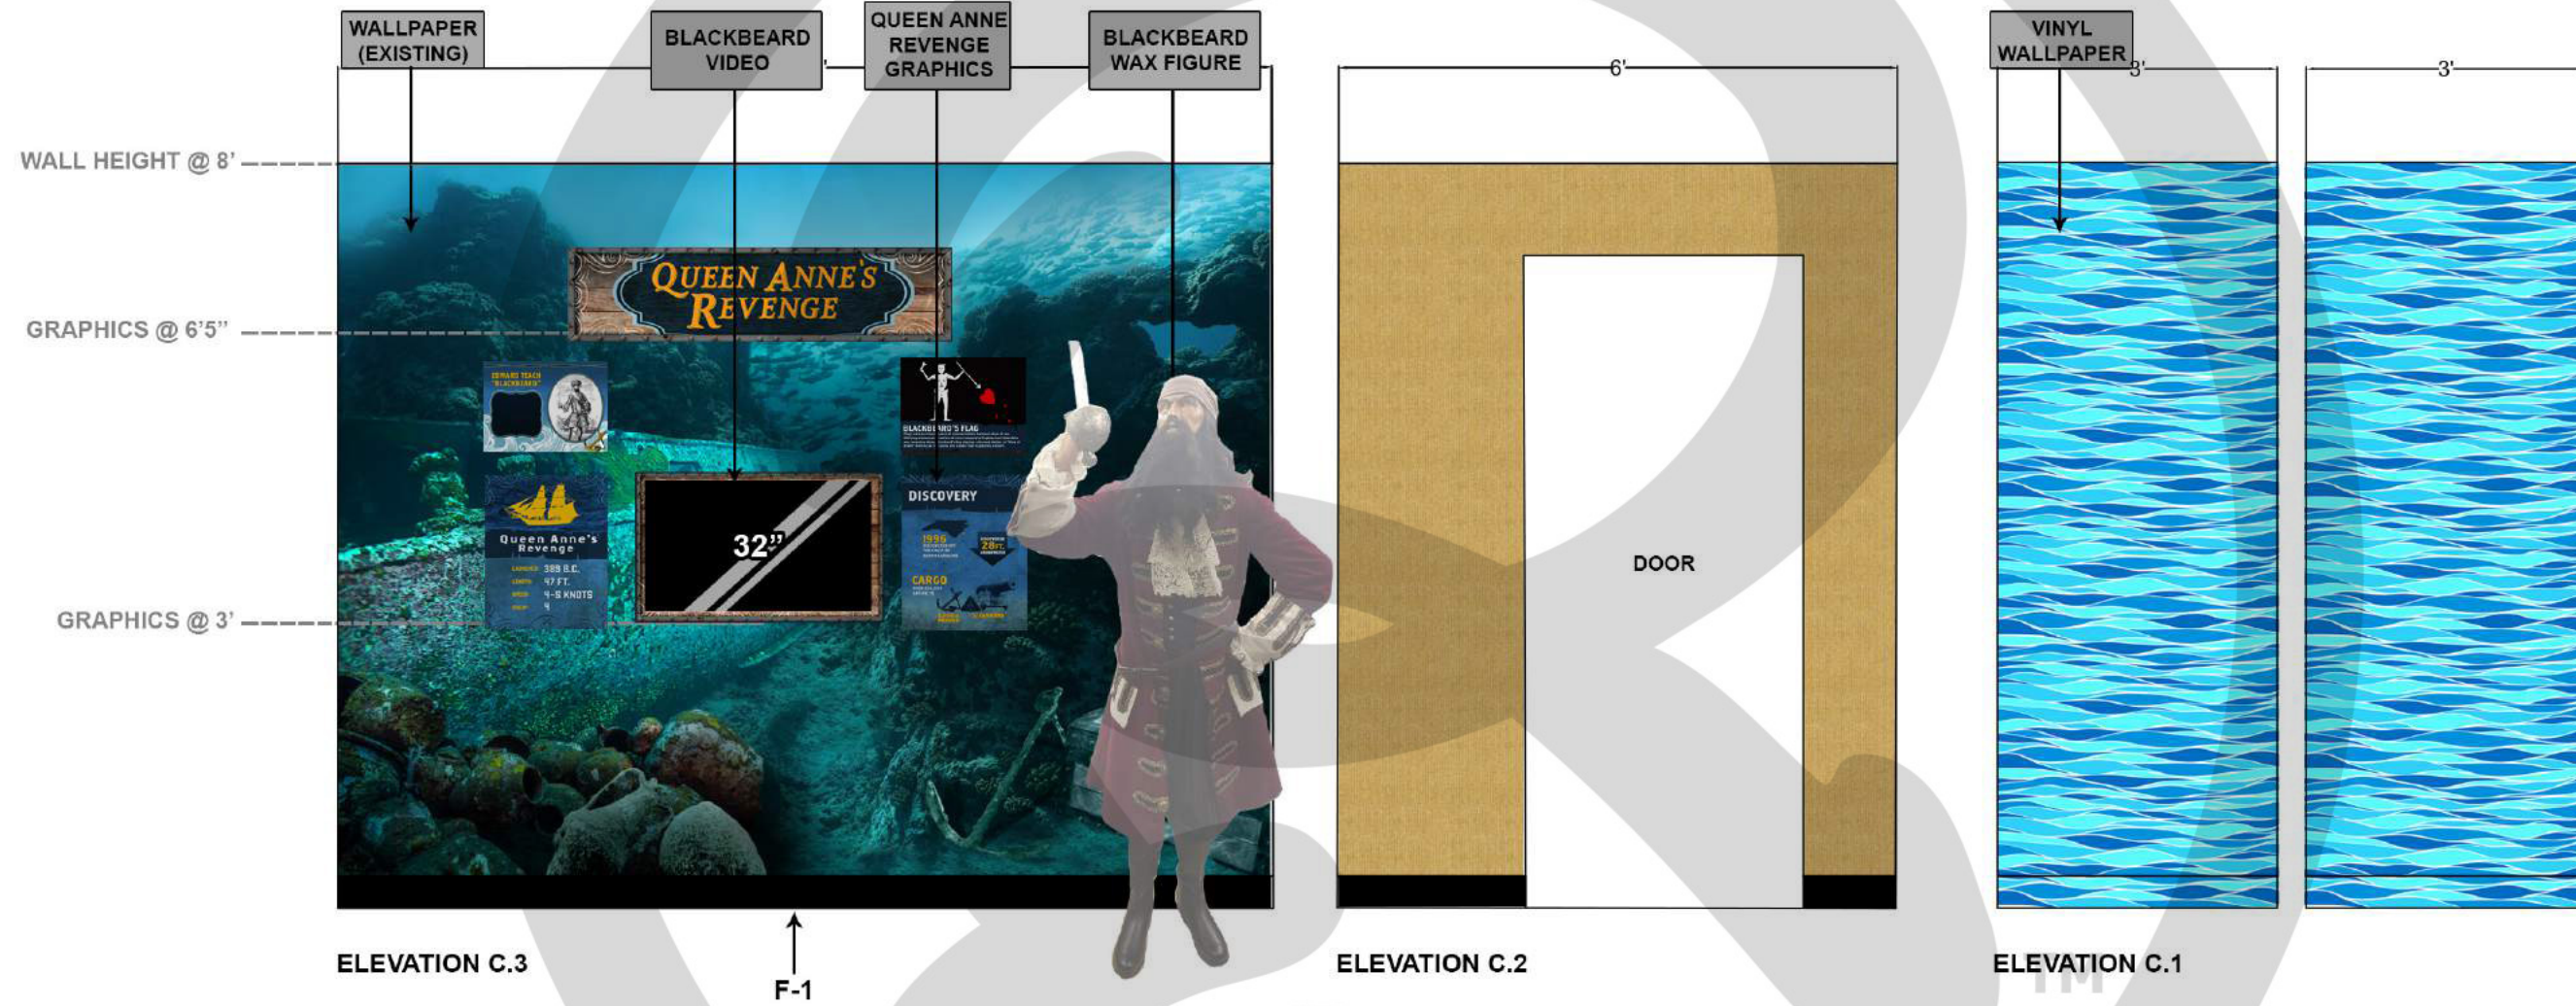

**F-1 [FINISH 1]**  
**FLEXCO Vinyl Wall Base**  
 BLACK  
 Item # 378981  
 lowes.com



**21** SHIPWRECKS-ELEVATION C.1 - C.3  
 SCALE: 1/2" = 1'

**RIPLEY**  
 ENTERTAINMENT, INC.  
 7576 KINGSPOINTE PKWY #188  
 ORLANDO, FLORIDA 32819  
 (407).345.8010  
 WWW.RIPLEYS.COM



PROJECT LOCATION:  
**GATLINBURG, TN**  
 NOTES:

PROJECT TITLE:

DATE:  
**2/19**  
 REVISED DATE:  
 SCALE: 1/2" = 1'

DRAWN BY:  
**CCOYLE**  
 APPROVED BY:

SHEET #  
 101.2.17  
 SW ELEVATION  
 C.1 - C.3

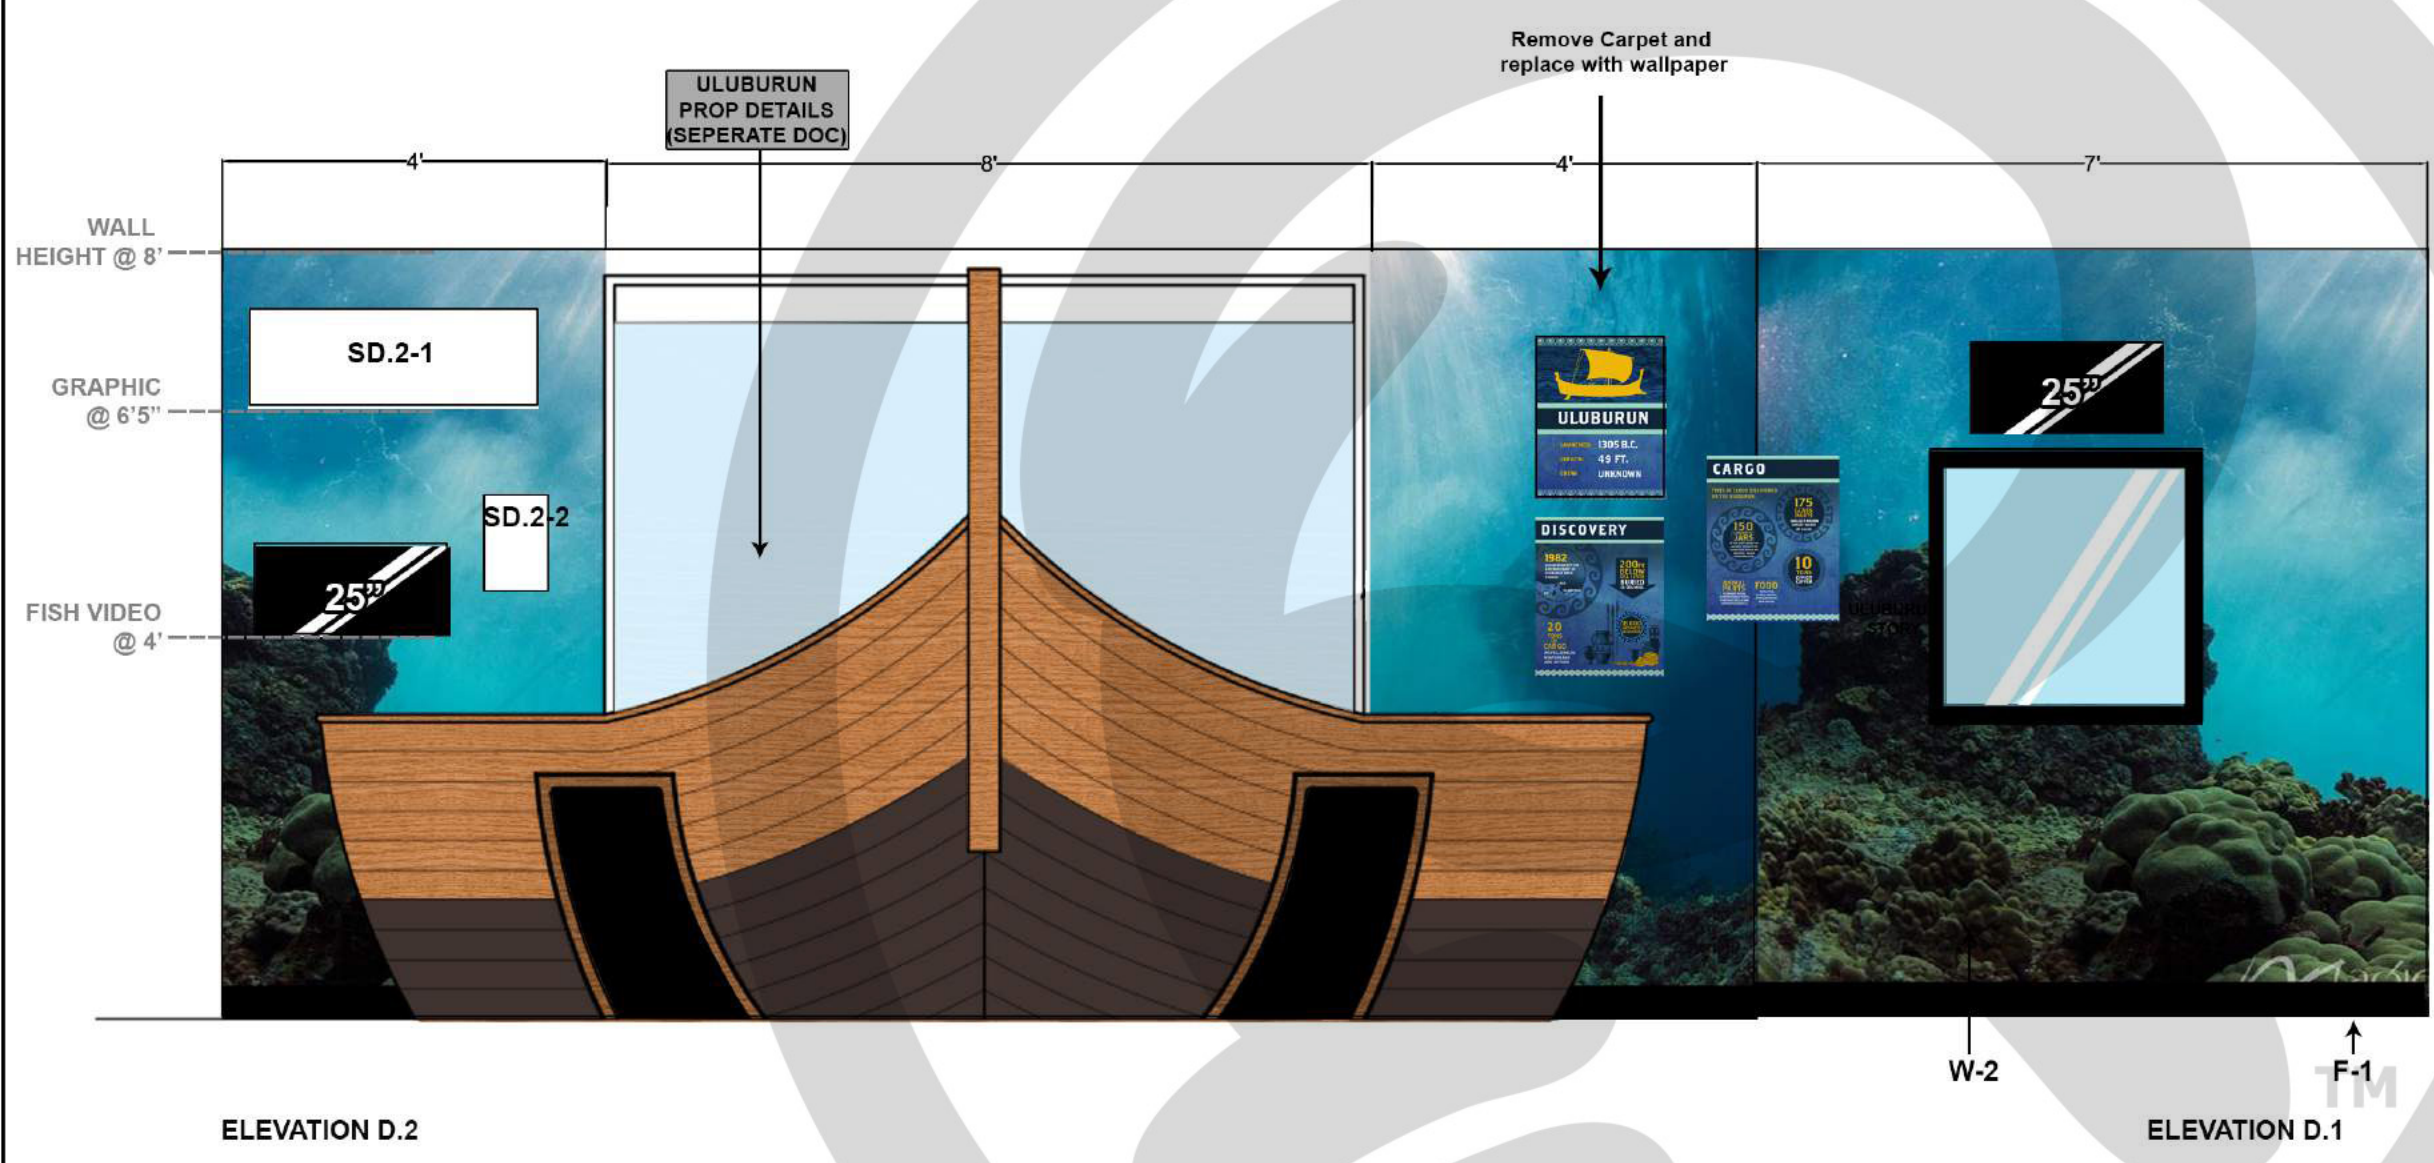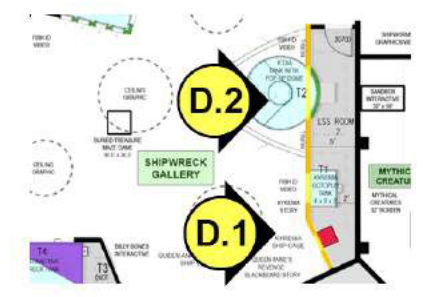

**F-1 [FINISH 1]**  
FLEXCO Vinyl Wall Base  
BLACK  
Item # 378981  
lowes.com

**WALLPAPER REFERENCE**

**W-2 [WALLPAPER 2]**  
ID: NGS-CPE2643357  
www.magicmurals.com

**22** SHIPWRECKS-ELEVATION D.1-D.2  
SCALE: 1/2" = 1'

**RIPLEY**  
ENTERTAINMENT, INC.  
7576 KINGSPOINTE PKWY #188  
ORLANDO, FLORIDA 32819  
(407).345.8010  
  
WWW.RIPLEYS.COM

PROJECT LOCATION:  
**GATLINBURG, TN**

NOTES:

PROJECT TITLE:

**Ripley's AQUARIUMS**

DATE:  
**2/19**

REVISED DATE:


SCALE: 1/2" = 1'

DRAWN BY:  
**CCOYLE**


APPROVED BY:

SHEET #

101.2.18  
SHIPWRECKS  
ELEVATION  
D.1-D.2

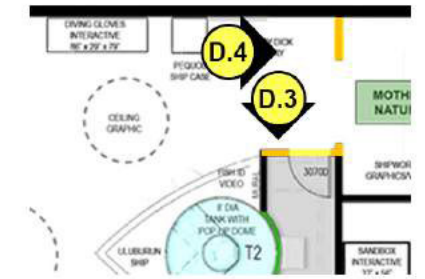

KEY ELEVATION  
SCALE: NOT TO SCALE

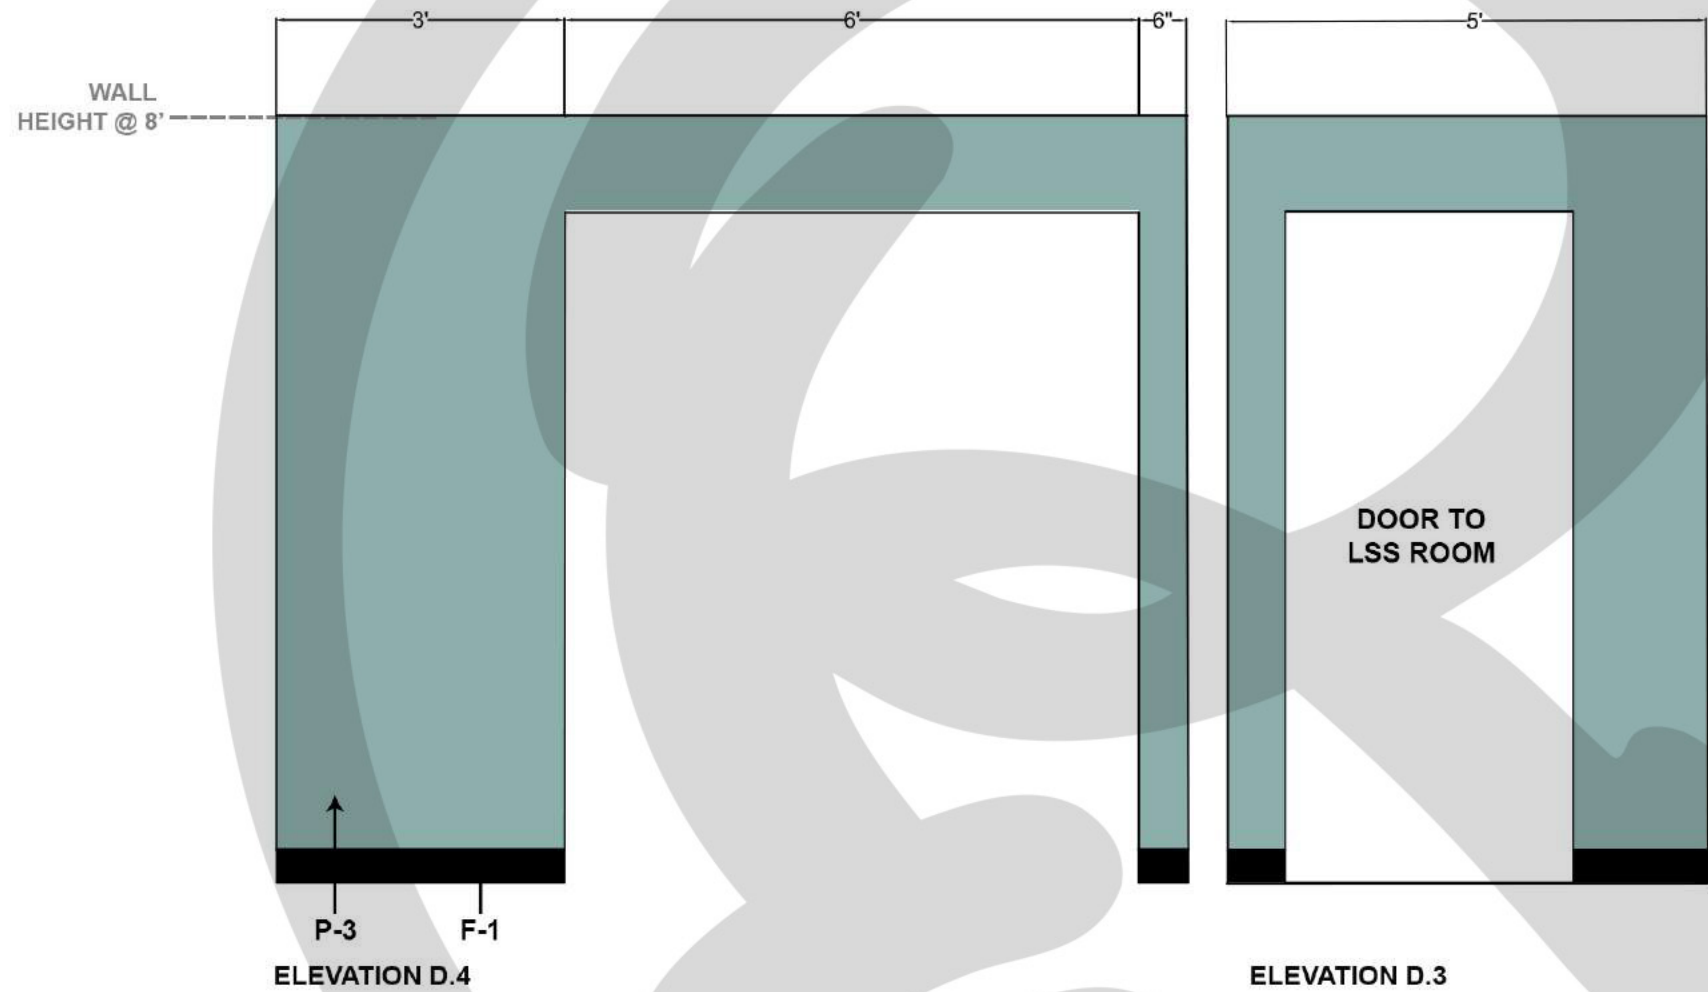

**P-3 [PAINT 3]**  
Drizzle  
SW 6479  
SATIN  
sherwin-williams.com

**F-1 [FINISH 1]**  
FLEXCO Vinyl Wall Base  
BLACK  
Item # 378981  
lowes.com

**23** SHIPWRECKS-ELEVATION D.3 & D.4  
SCALE: 1/2" = 1'

**RIPLEY**  
ENTERTAINMENT, INC.  
7576 KINGSPOINTE PKWY #188  
ORLANDO, FLORIDA 32819  
(407).345.8010  
  
WWW.RIPLEYS.COM

PROJECT LOCATION:  
**GATLINBURG, TN**  
  
NOTES:

PROJECT TITLE:  
  
**Ripley's  
AQUARIUMS**

DATE:  
**2/19**  
REVISED DATE:  
  
SCALE: 1/2" = 1'

DRAWN BY:  
**CCOYLE**  
  
APPROVED BY:


SHEET #  
  
101.2.19  
SW  
ELEVATION  
D.3 & D.4





### NOTES

- CUTOUTS ARE 7" x 9"
- BACK AND SIDES TO BE COVERED WITH LAMINATE
- APPLY VINYL TO FRONT ONLY. GRAPHICS TBD

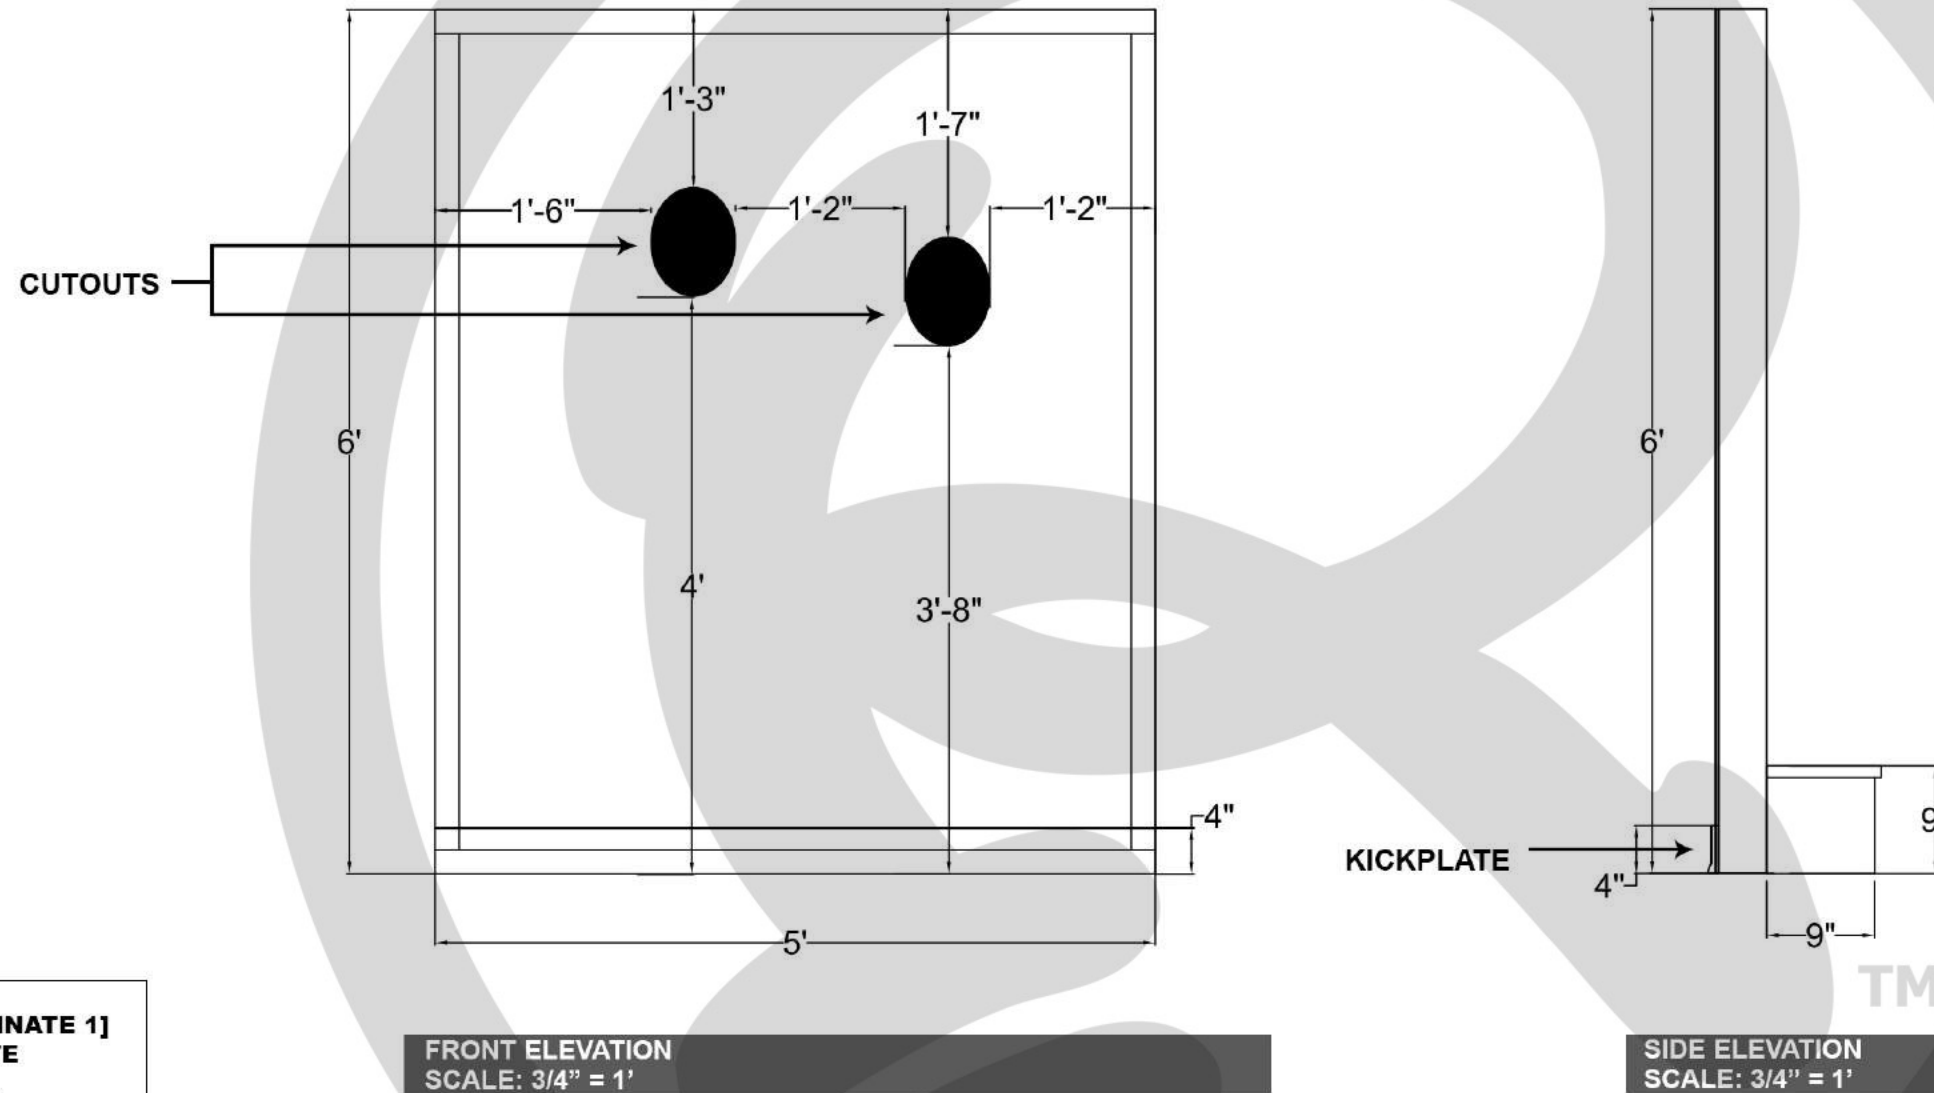

### FINISH REFERENCE



**L-1 [LAMINATE 1]**  
**ARBORITE**  
 S-568 CA  
 MIDNIGHT BLUE

**24** PIRATE PHOTO OP DETAILS  
 SCALE: 3/4" = 1'

**RIPLEY**  
 ENTERTAINMENT, INC.  
 7576 KINGSPONTE PKWY #188  
 ORLANDO, FLORIDA 32819  
 (407).345.8010  
 WWW.RIPLEYS.COM



PROJECT LOCATION:  
**GATLINBURG, TN**  
 NOTES:

PROJECT TITLE:

DATE:  
**2/19**  
 REVISED DATE:  
 SCALE:  
 3/4" = 1'

DRAWN BY:  
**CCOYLE**  
 APPROVED BY:

SHEET #  
**101.3.1**  
**PIRATE**  
**PHOTO-OP**  
**DETAILS**

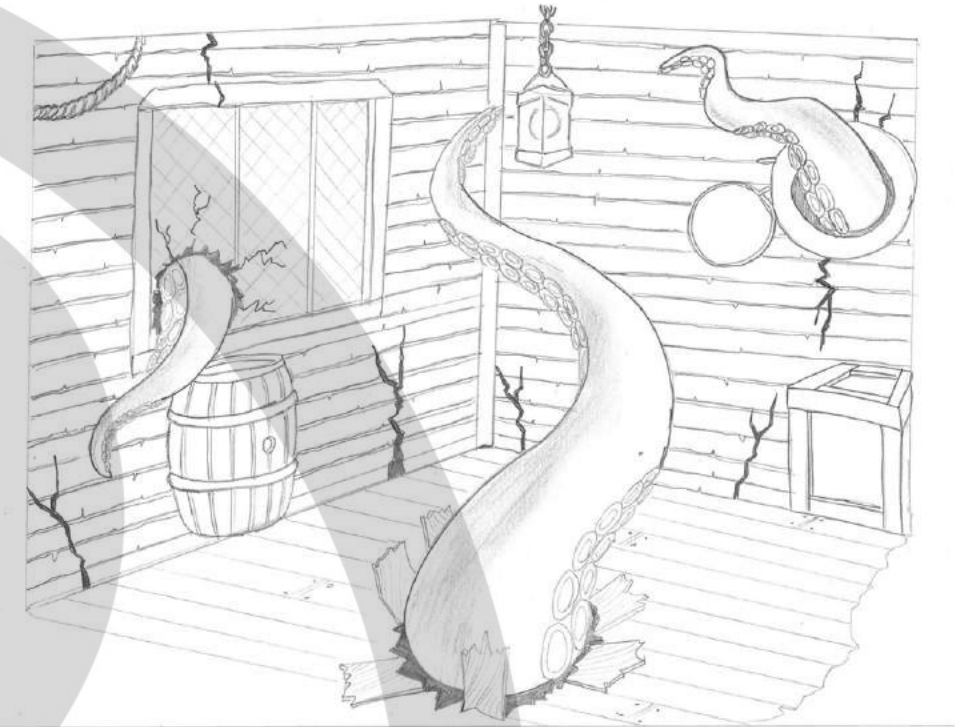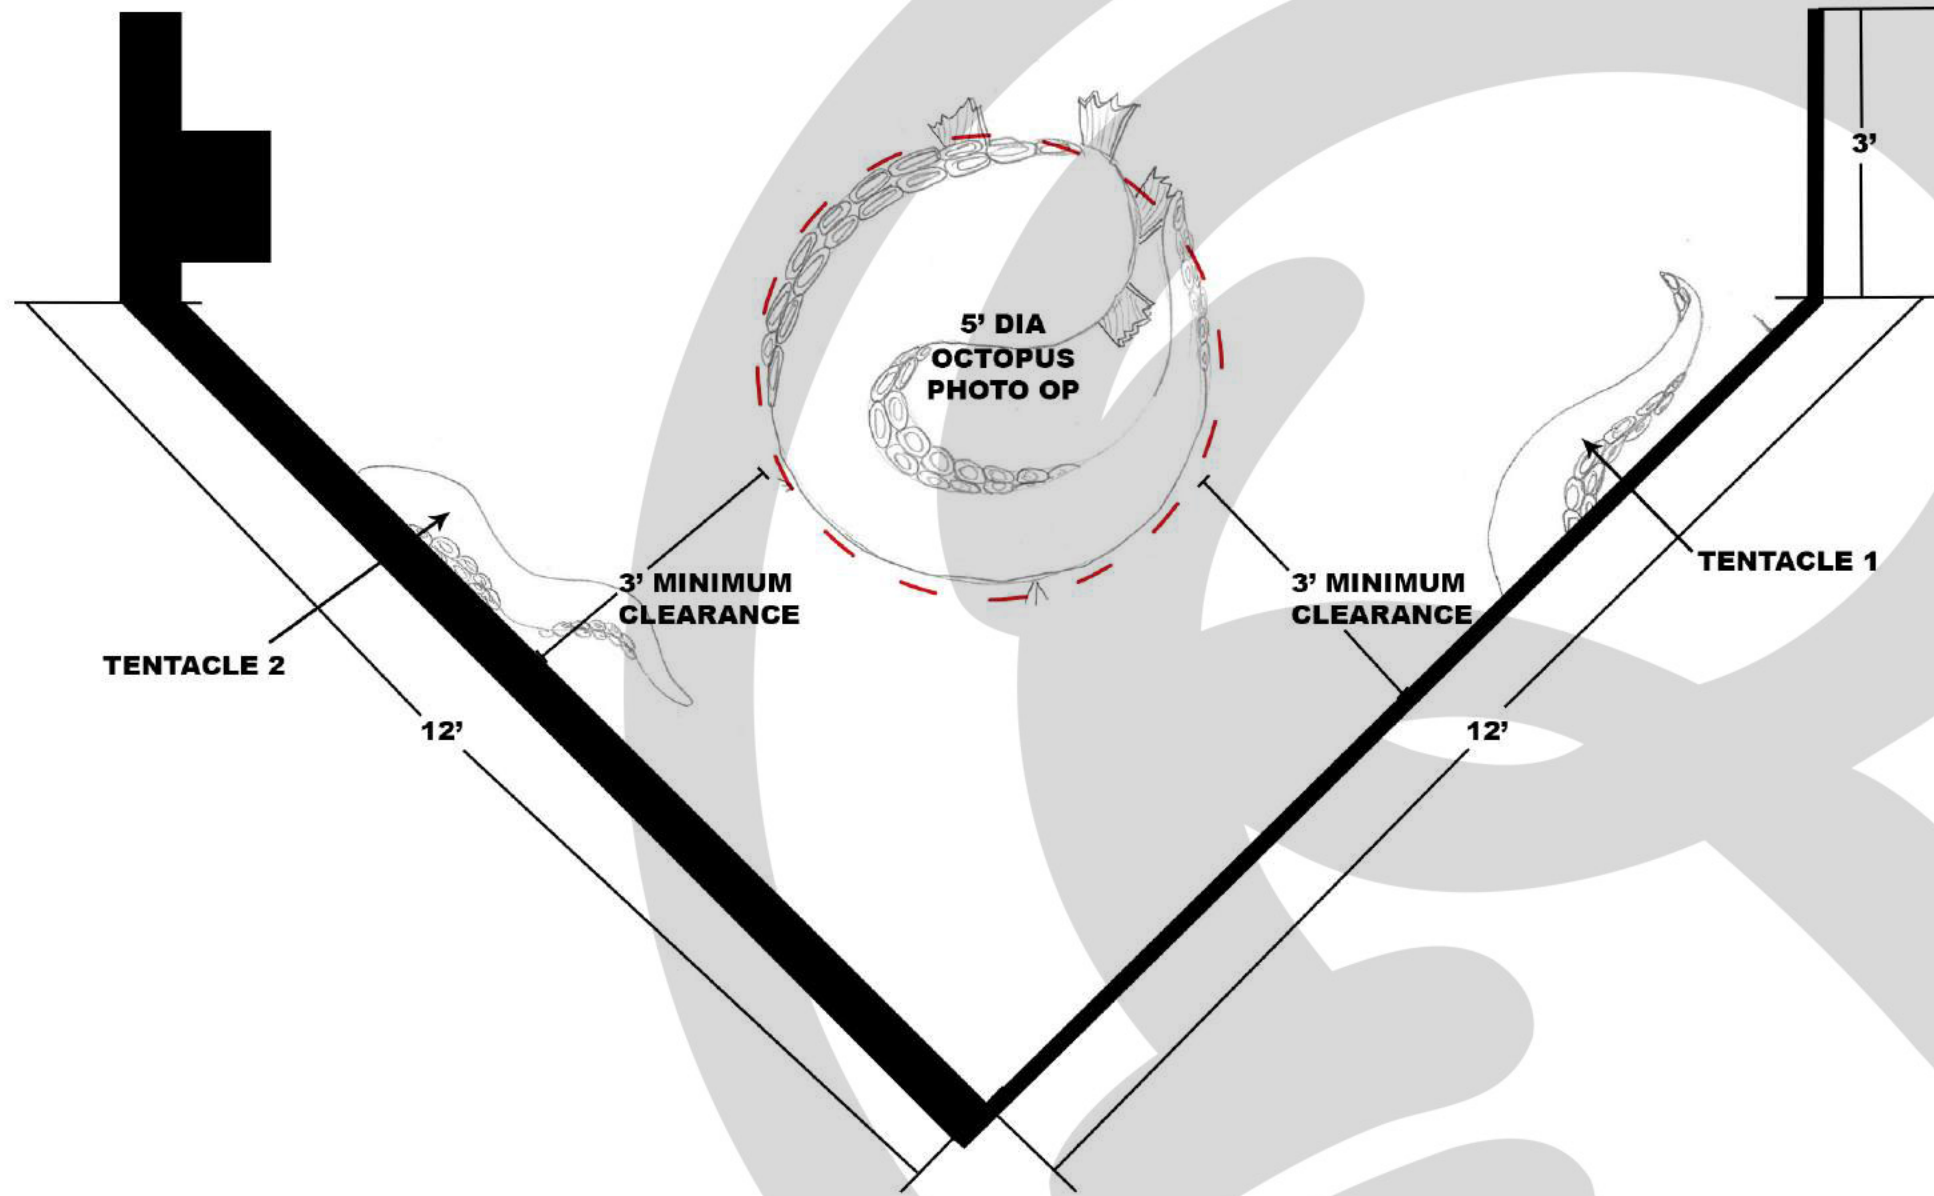

**CONCEPT RENDER (BY STEVE BRAUCH)**  
**SCALE: NOT TO SCALE**

**TOP ELEVATION**  
**SCALE: 1/2" = 1'**

**25** OCTOPUS PHOTO OP DETAILS  
 SCALE: 3/4" = 1'

**RIPLEY**  
 ENTERTAINMENT, INC.  
 7576 KINGSPONTE PKWY #188  
 ORLANDO, FLORIDA 32819  
 (407).345.8010  
 WWW.RIPLEYS.COM

PROJECT LOCATION:  
**GATLINBURG, TN**  
 NOTES:

PROJECT TITLE:

DATE:  
**2/19**  
 REVISED DATE:  
 SCALE:  
 3/4" = 1'


DRAWN BY:  
**CCOYLE**  
 APPROVED BY:

SHEET #  
**101.3.2**  
**OCTOPUS**  
**PHOTO-OP**  
**DETAILS**



**REQUESTED ADJUSTMENTS**

- Paint screws black on the front.
- Add foam or cushion insert to soften sound of bone pieces when hitting bottom of cabinet.

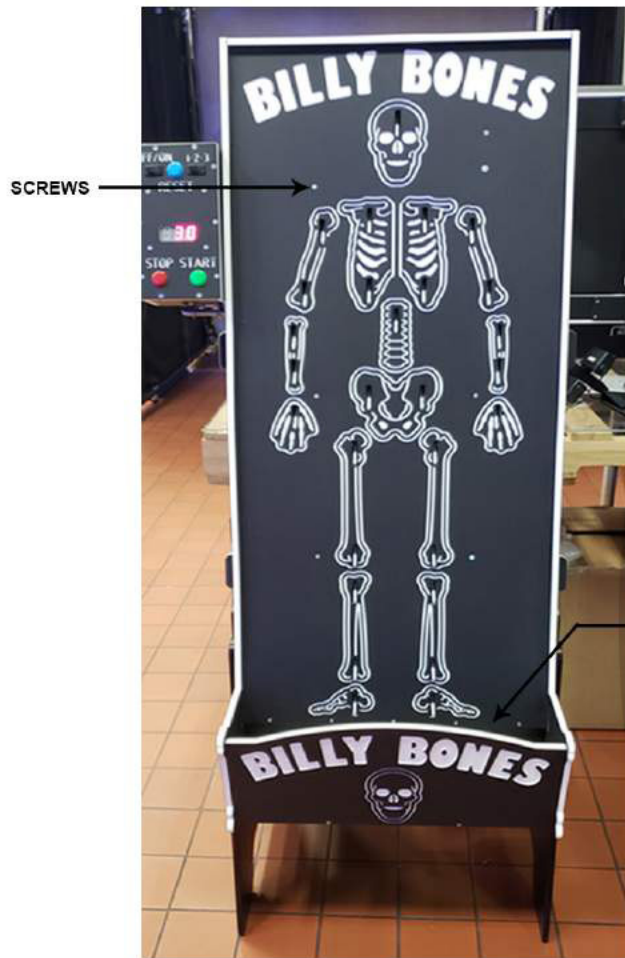

FRONT

**REQUESTED ADJUSTMENTS**

- Have ON/OFF button accessed from the side instead of the front.
- Cabinet needs to mount flush against wall for mounting.



SIDE

**REQUESTED ADJUSTMENTS**

- Move ON/OFF button to the side where an access panel will be located.
- Remove the 1-2-3 button. The game needs to be set at 60 seconds without option for adjustment.




INSTRUCTION PANEL



**NOTES**

-Use a black laminate to cover cabinet.

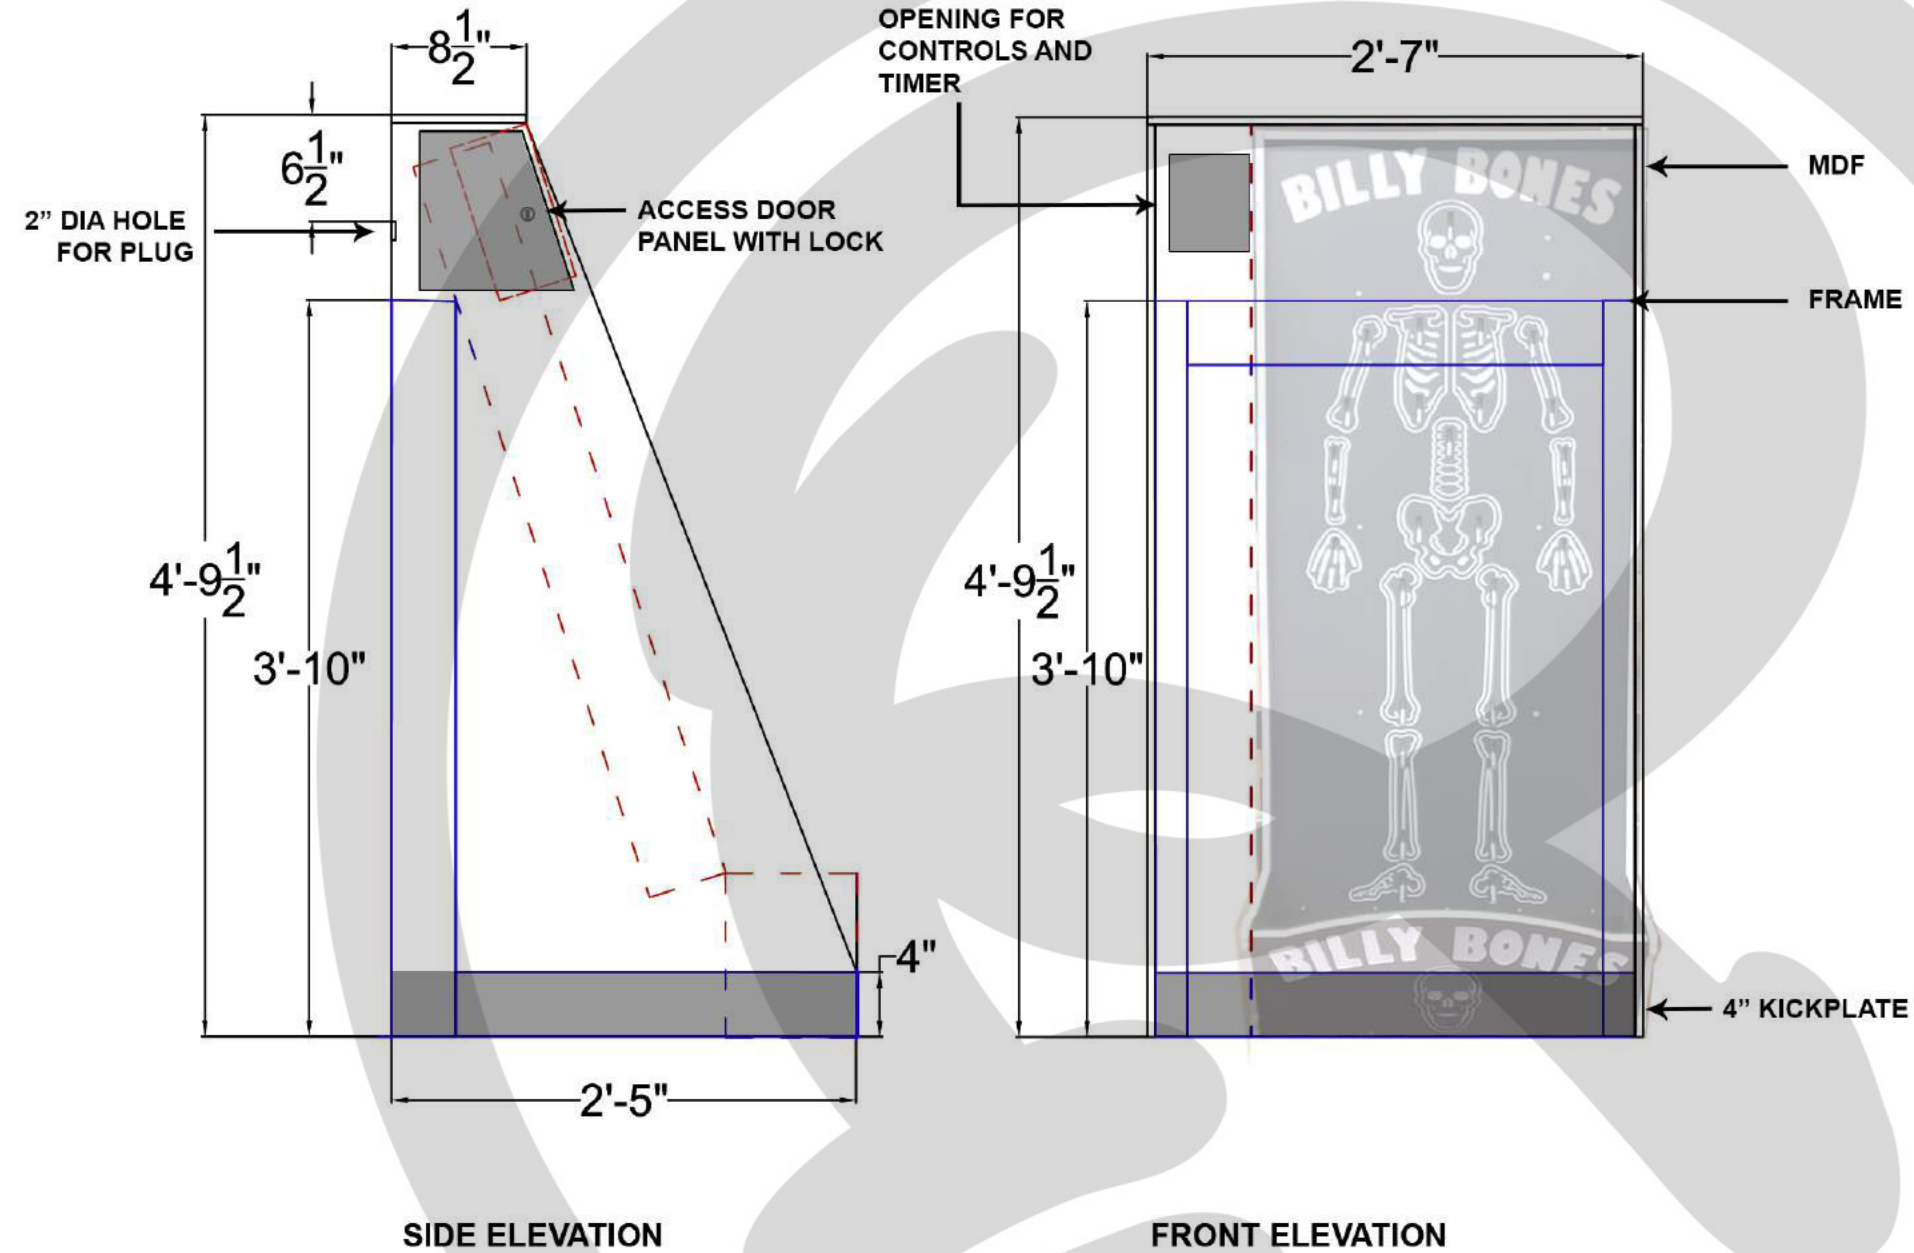

**27** BILLY BONES INTERACTIVE DETAILS B  
SCALE: 1" = 1'

**RIPLEY**  
ENTERTAINMENT, INC.  
7576 KINGSPONTE PKWY #188  
ORLANDO, FLORIDA 32819  
(407).345.8010  
  
WWW.RIPLEYS.COM


PROJECT LOCATION:  
**GATLINBURG, TN**  
  
NOTES:

PROJECT TITLE:  
  


DATE:  
**2/19**  
REVISED DATE:  
  
SCALE: 1" = 1'

DRAWN BY:  
**CCOYLE**  
  
APPROVED BY:

SHEET #  
  
**101.3.3B**  
**BILLY BONES**  
**INTERACTIVE**  
**DETAILS**

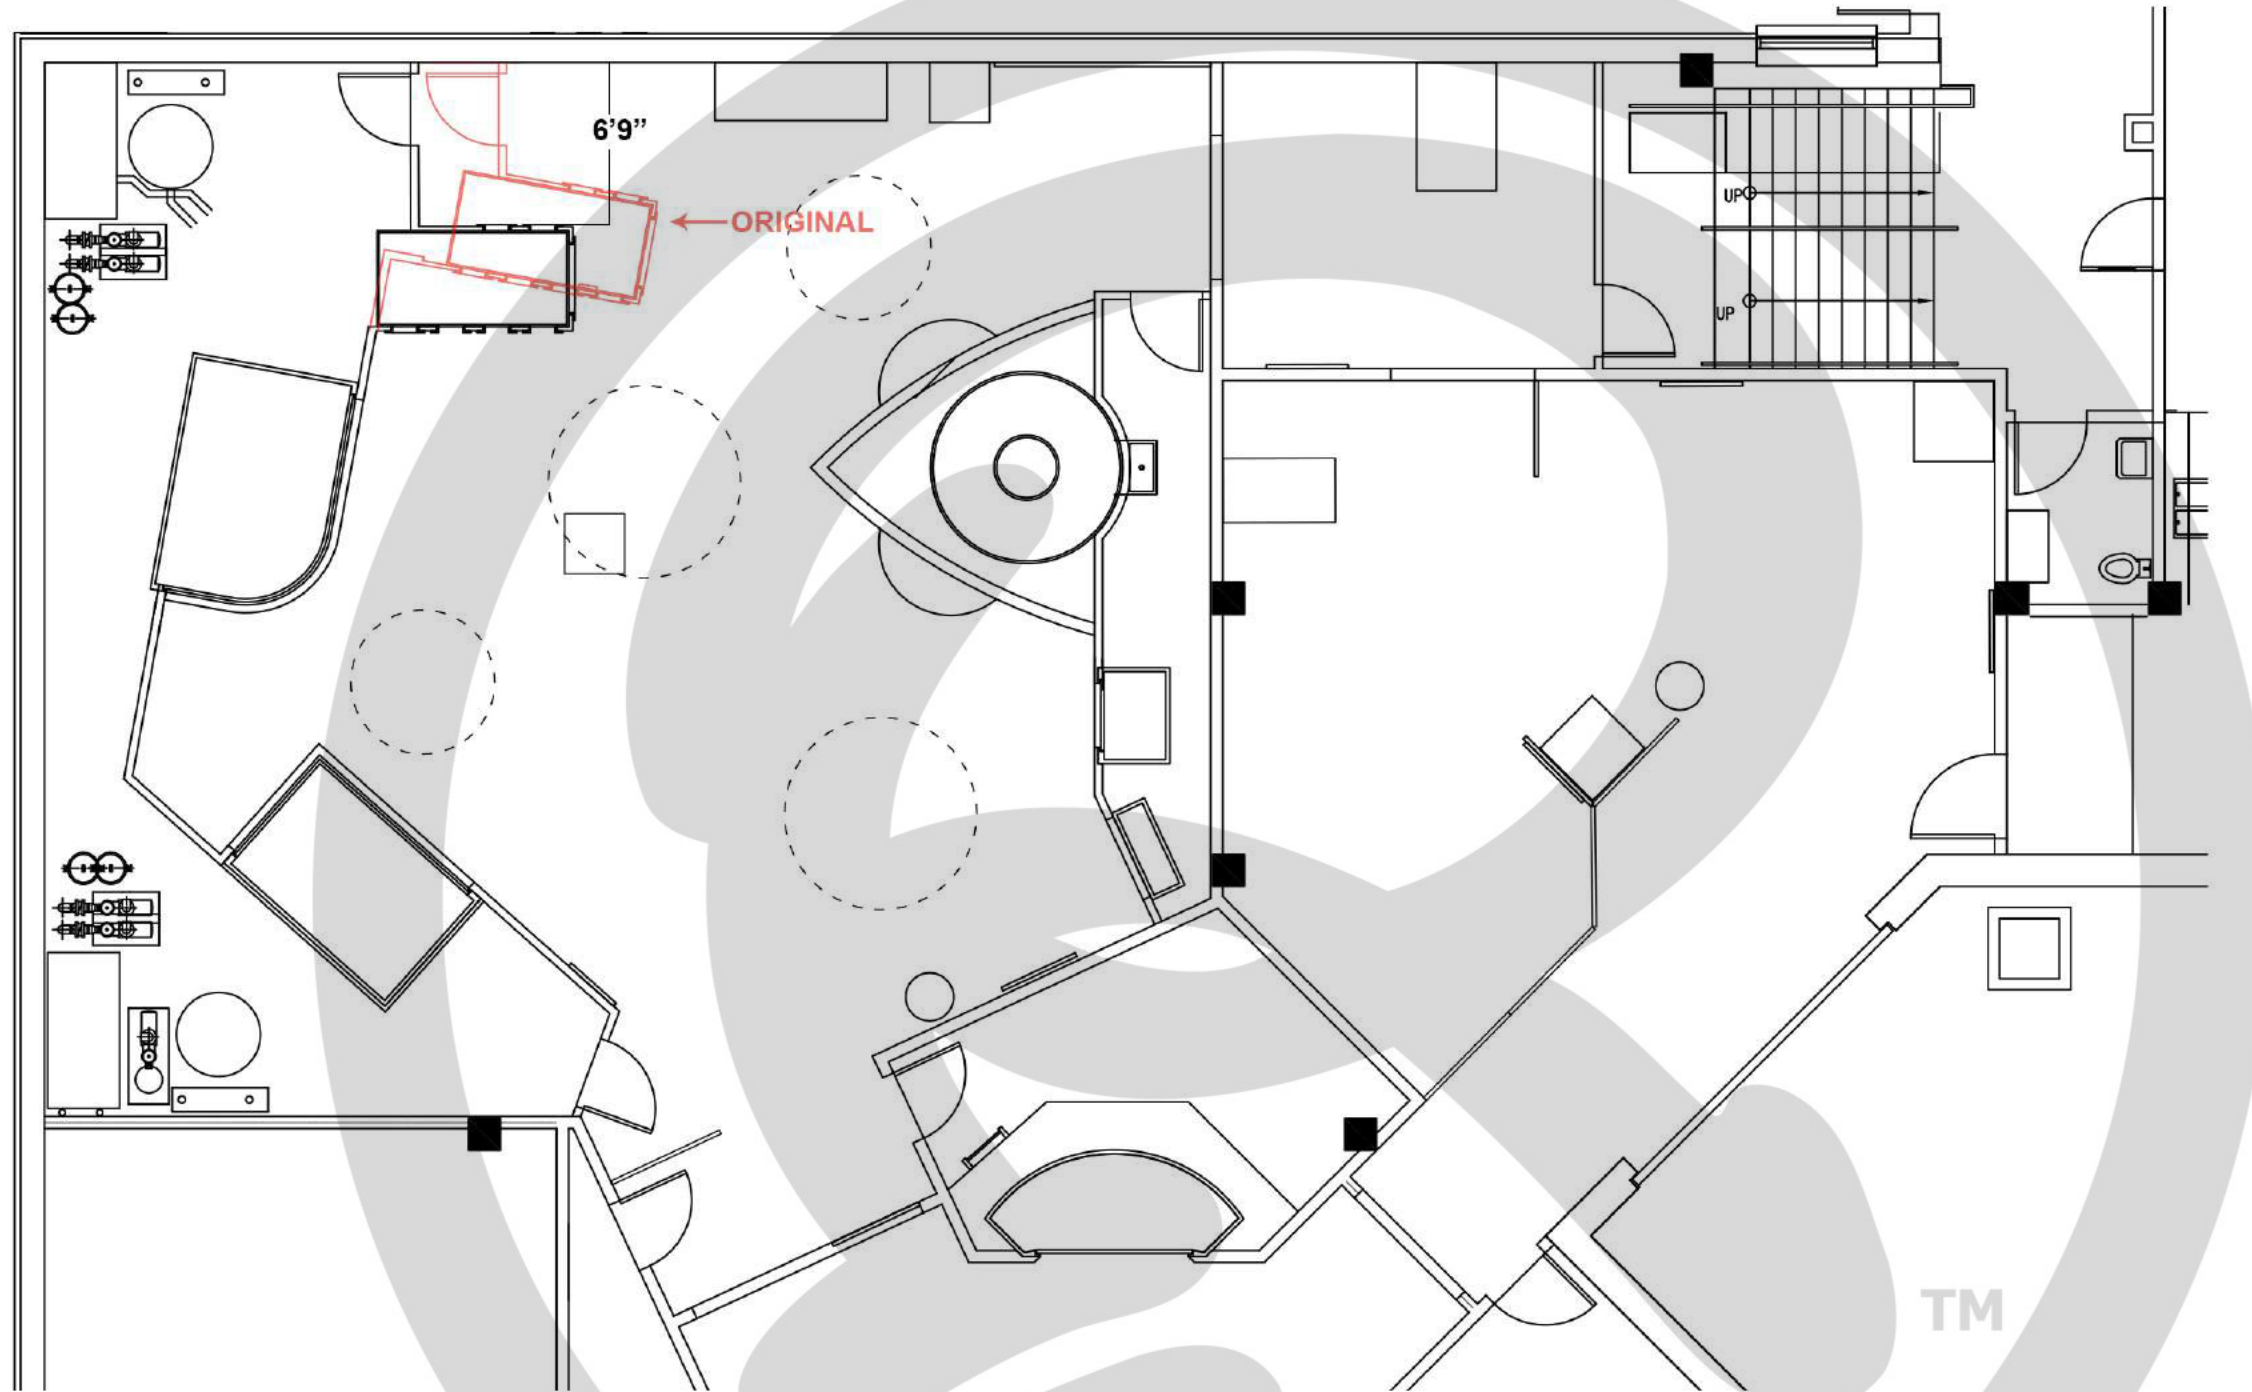

TM

**28** SUBMARINE TANK LAYOUT  
SCALE: 1/8" = 1'

**RIPLEY**  
ENTERTAINMENT, INC.  
7576 KINGSPONTE PKWY #188  
ORLANDO, FLORIDA 32819  
(407).345.8010  
  
WWW.RIPLEYS.COM


PROJECT LOCATION:  
**GATLINBURG, TN**  
  
NOTES:

PROJECT TITLE:  
  
**Ripley's**  
**AQUARIUMS**

DATE:  
**2/19**  
REVISED DATE:  
  
SCALE: 1/8" = 1'

DRAWN BY:  
**CCOYLE**  
  
APPROVED BY:

SHEET #  
  
**101.3.4A**  
**SUBMARINE**  
**TANK**  
**LAYOUT**

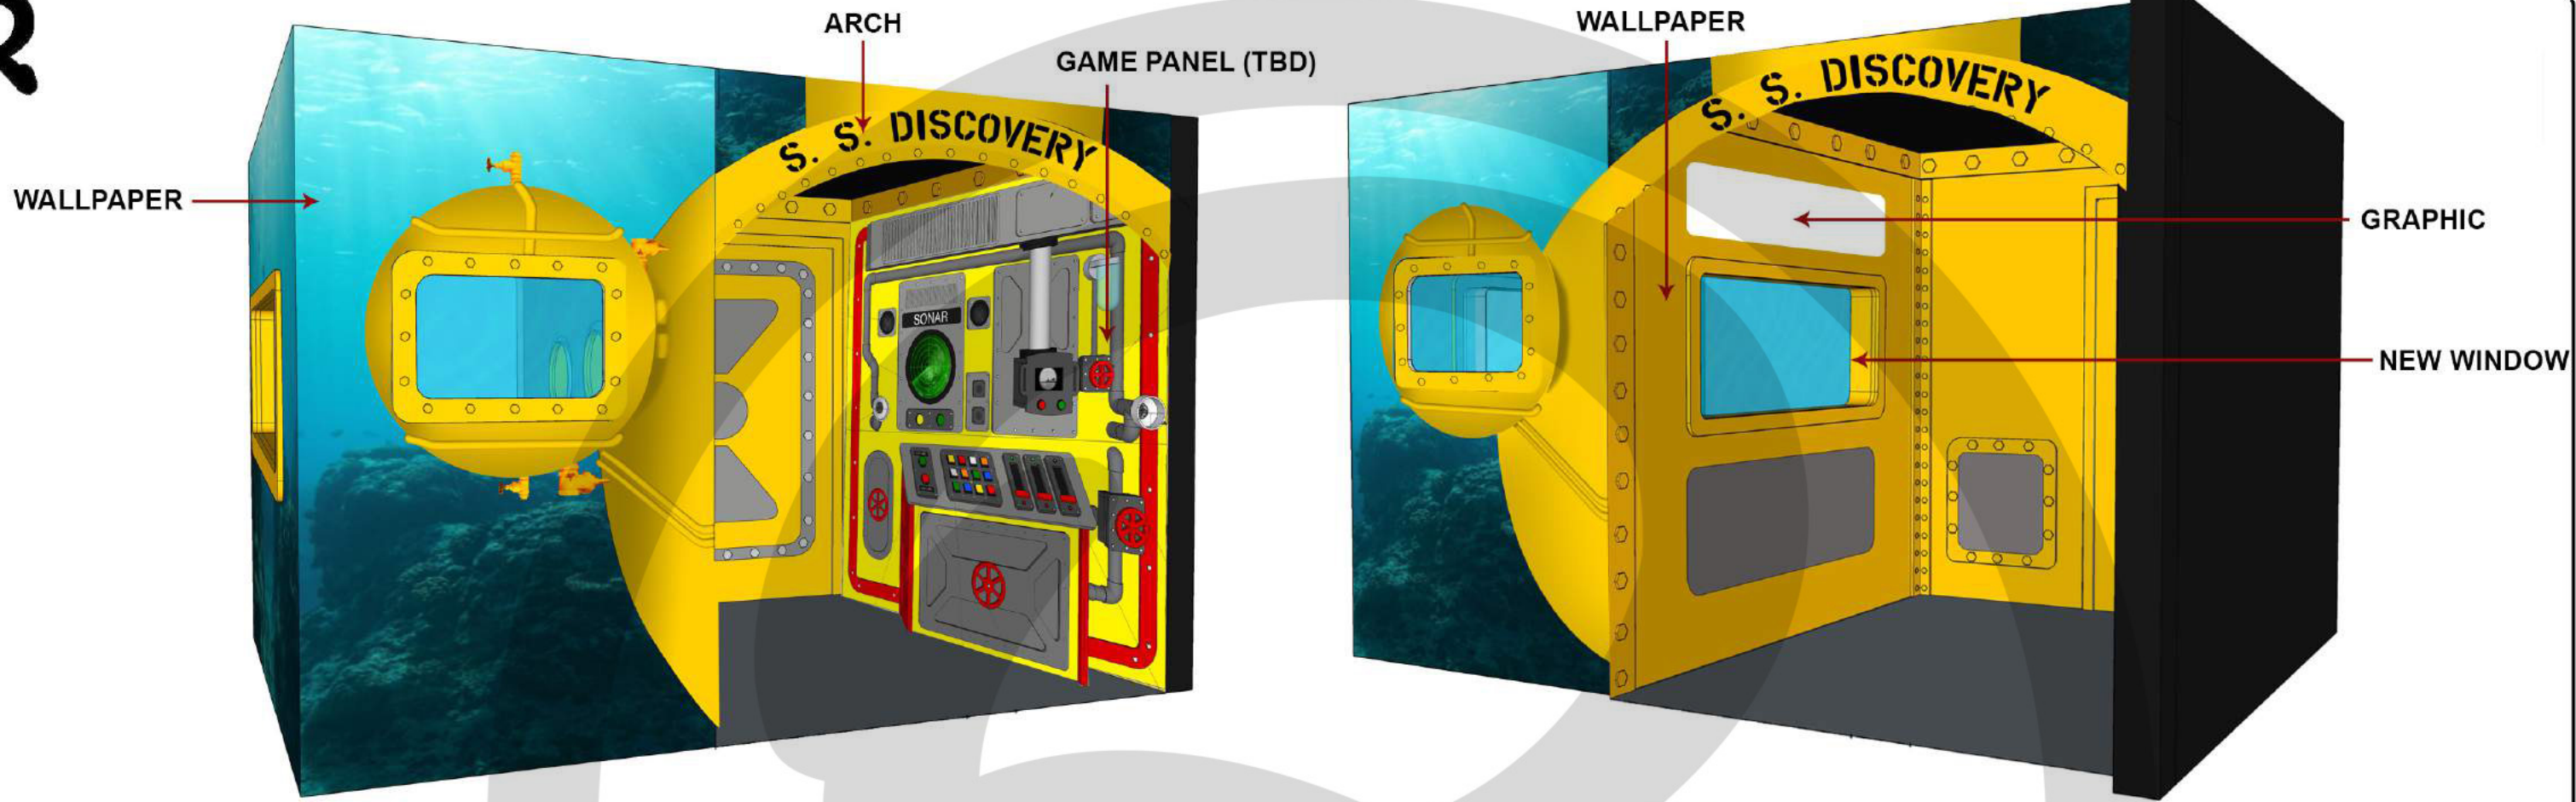


**NOTES**

- Wallpaper on the tank and arch.
- PVC graphics will be added to support theming as necessary.

**MILLWORK**

- Window for photo op
- Step for porthole interactive
- Buttons for porthole need to move from outside tank to the inside of the tank.

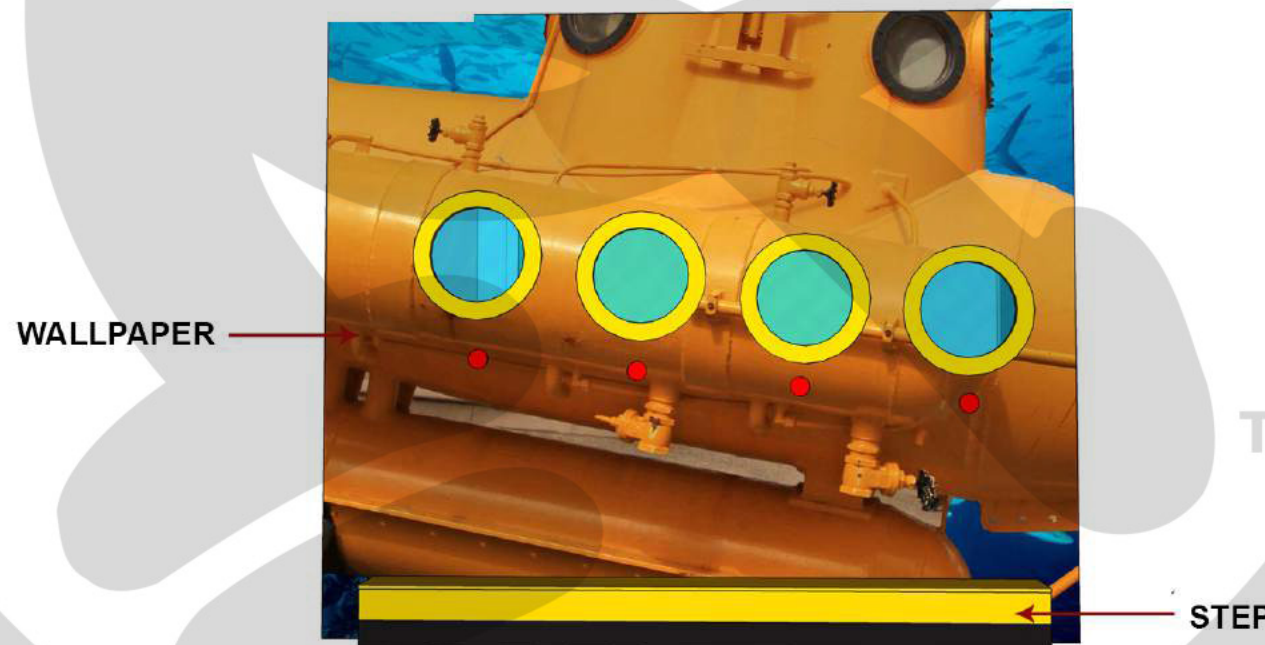

**29** SUBMARINE INTERACTIVE CONCEPT  
SCALE: NOT TO SCALE

**RIPLEY**  
ENTERTAINMENT, INC.  
7576 KINGSPOINTE PKWY #188  
ORLANDO, FLORIDA 32819  
(407).345.8010  
  
WWW.RIPLEYS.COM

PROJECT LOCATION:  
**GATLINBURG, TN**  
  
NOTES:

PROJECT TITLE:  
  


DATE:  
**2/19**  
REVISED DATE:  
  
SCALE: NOT TO SCALE



DRAWN BY:  
**CCOYLE**  
  
APPROVED BY:

SHEET #  
  
**101.3.4B**  
**SUBMARINE**  
**TANK**  
**CONCEPT**



**NOTES**

-Secure step with L-bracket from the back to the tank.

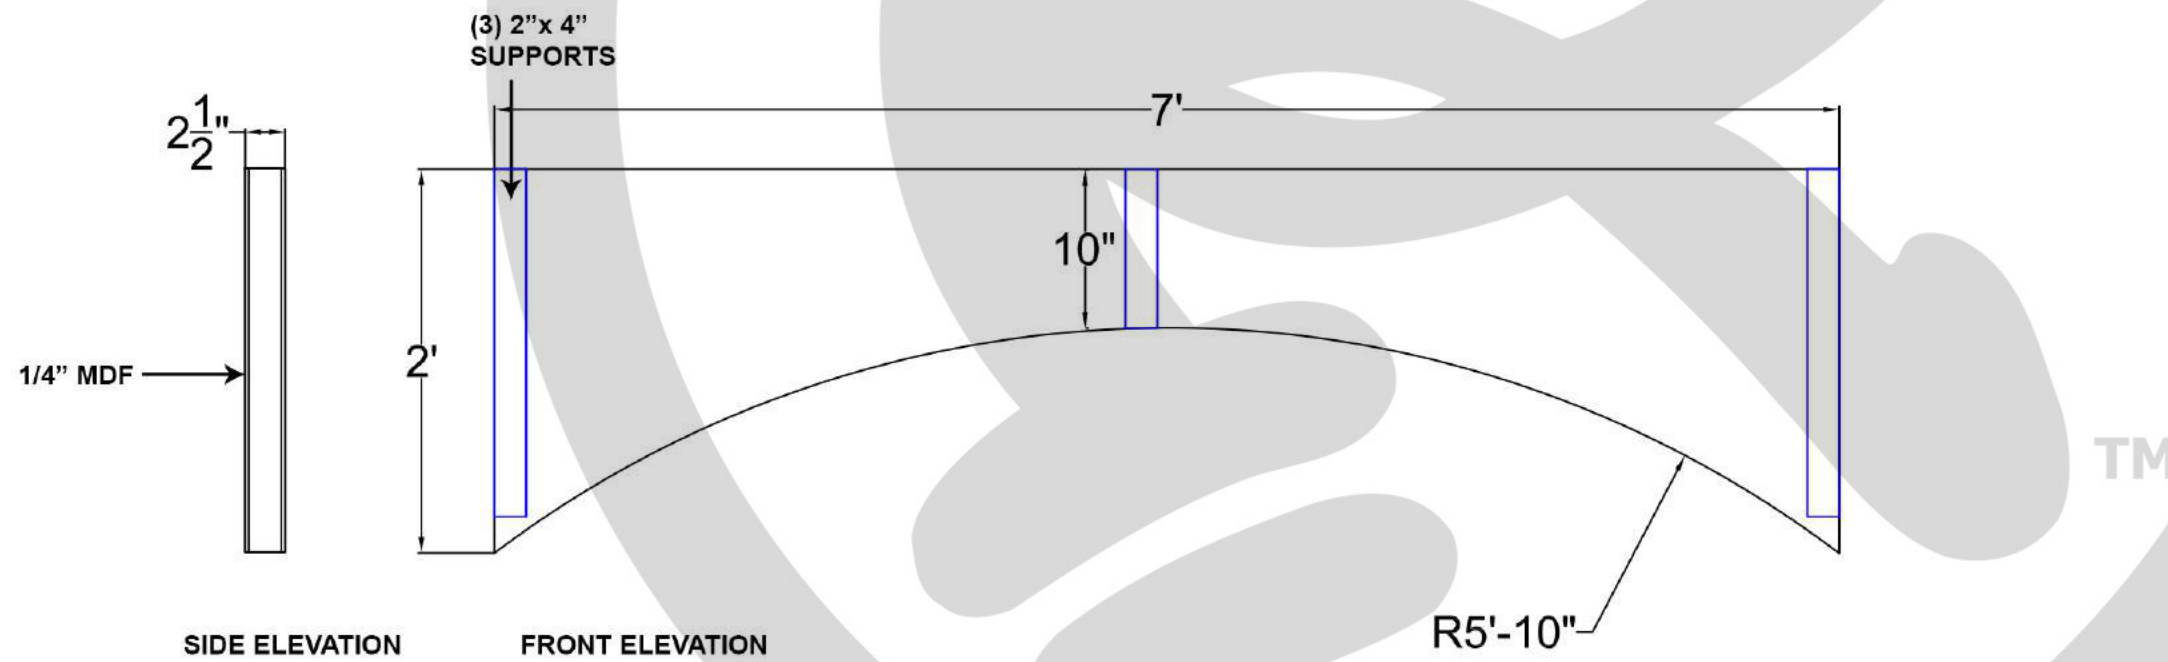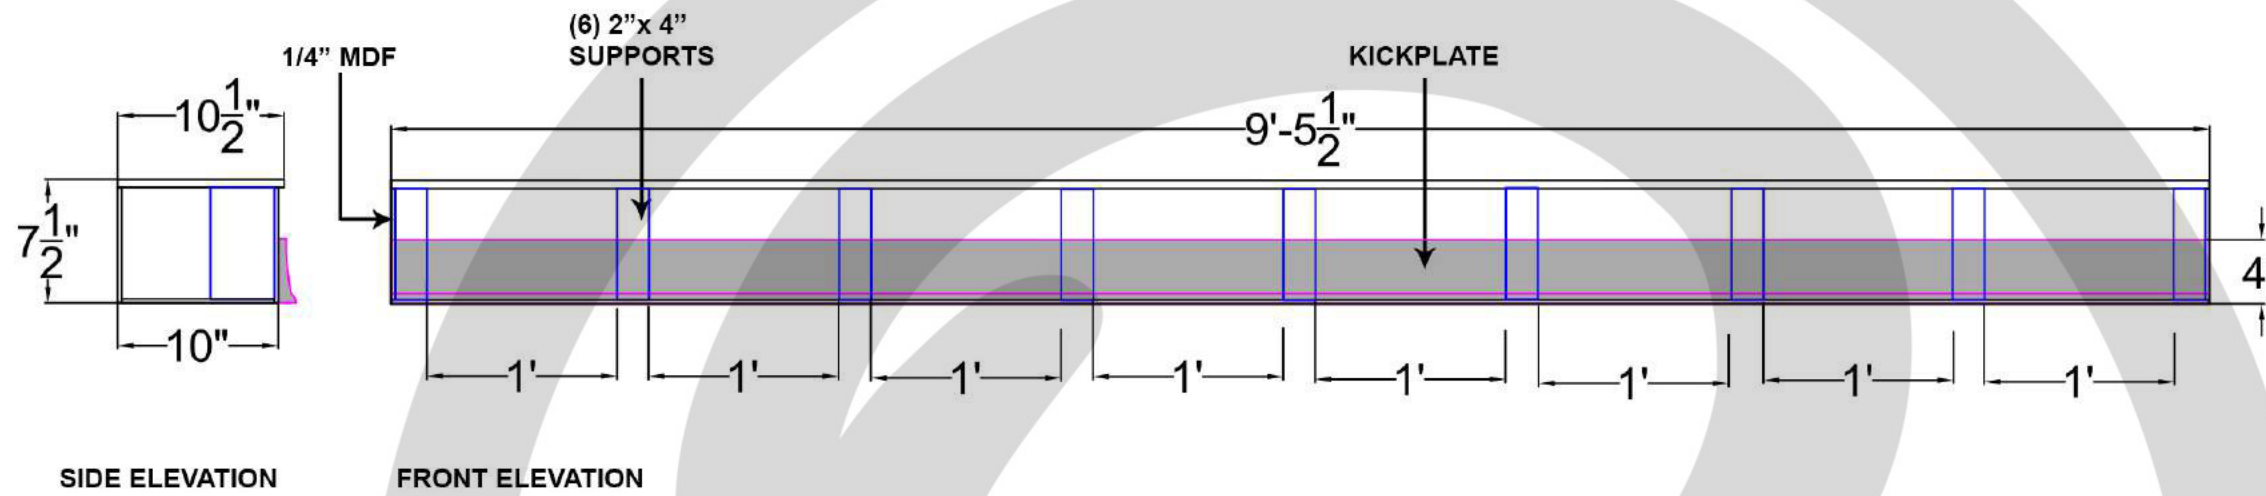

**30** SUBMARINE MILLWORK  
SCALE: 1"=1'

**RIPLEY**  
ENTERTAINMENT, INC.  
7576 KINGSPOINTE PKWY #188  
ORLANDO, FLORIDA 32819  
(407).345.8010  
  
WWW.RIPLEYS.COM

PROJECT LOCATION:  
**GATLINBURG, TN**  
  
NOTES:

PROJECT TITLE:

DATE:  
**2/19**  
REVISED DATE:  
  
SCALE: 1" = 1'

DRAWN BY:  
**CCOYLE**  
  
APPROVED BY:

SHEET #  
  
101.3.4C  
SUBMARINE  
MILLWORK